

Copyright
 This drawing and any design here on is the copyright of the Consultants and must not be reproduced without their written consent. All drawings remain the property of the Consultants.

THIS DRAWING TO BE READ IN CONJUNCTION WITH ALL RELEVANT ARCHITECTS AND ENGINEERS DRAWINGS.

FIGURED DIMENSIONS ONLY TO BE TAKEN FROM THIS DRAWING.

ALL LEVELS ARE IN METRES AND RELATE TO DATUM AT MALIN HEAD.

THIS DRAWING IS REPRODUCED FROM DIGITAL MAPS:
 O.S. MAPS - Scale 1:2,500
 O.S. MAPS - Scale 1:1,000
 DISCOVERY SERIES - Scale 1:50,000

ALL MAPS ARE REFERENCED TO IRISH NATIONAL GRID (I.T.M.)


REPRODUCED FROM THE ORDNANCE SURVEY OF IRELAND BY PERMISSION OF THE GOVERNMENT. LICENSE NO. 3-3-34.

THIS DRAWING IS A COPY OF AN ELECTRONIC FILE AND IS COPYRIGHT.


ALL DIMENSIONS TO BE CHECKED ON SITE.

ALL MATERIALS AND WORKMANSHIP TO BE IN ACCORDANCE WITH ENGINEERS SPECIFICATION.


IT IS THE CONTRACTORS RESPONSIBILITY TO VERIFY ALL DIMENSIONS AND LEVELS PRIOR TO COMMENCEMENT OF CONSTRUCTION.

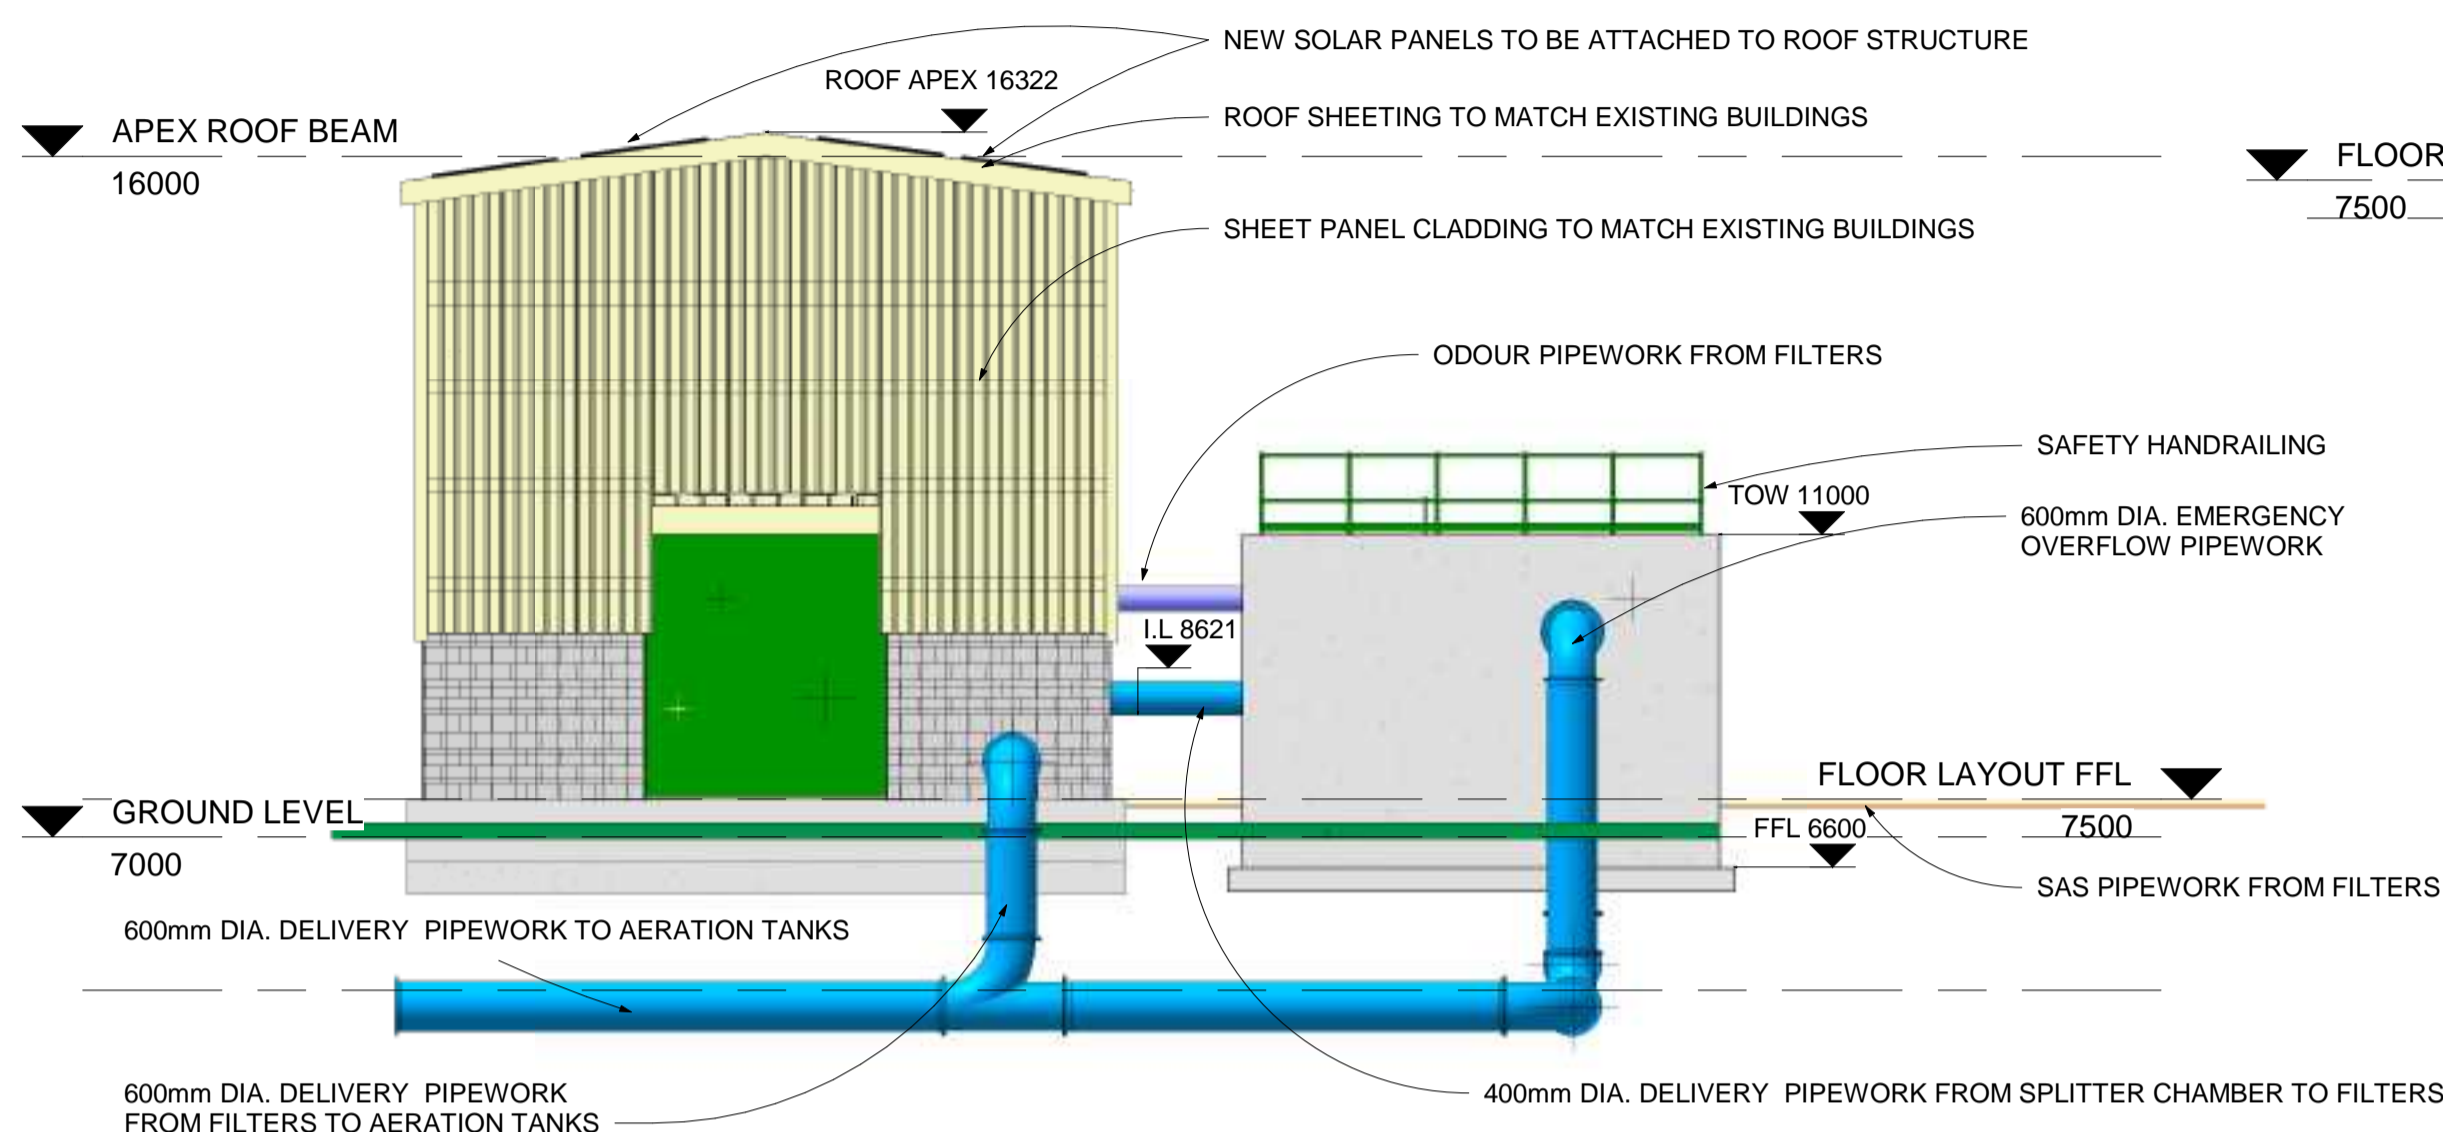


1 East Elevation
1 : 100

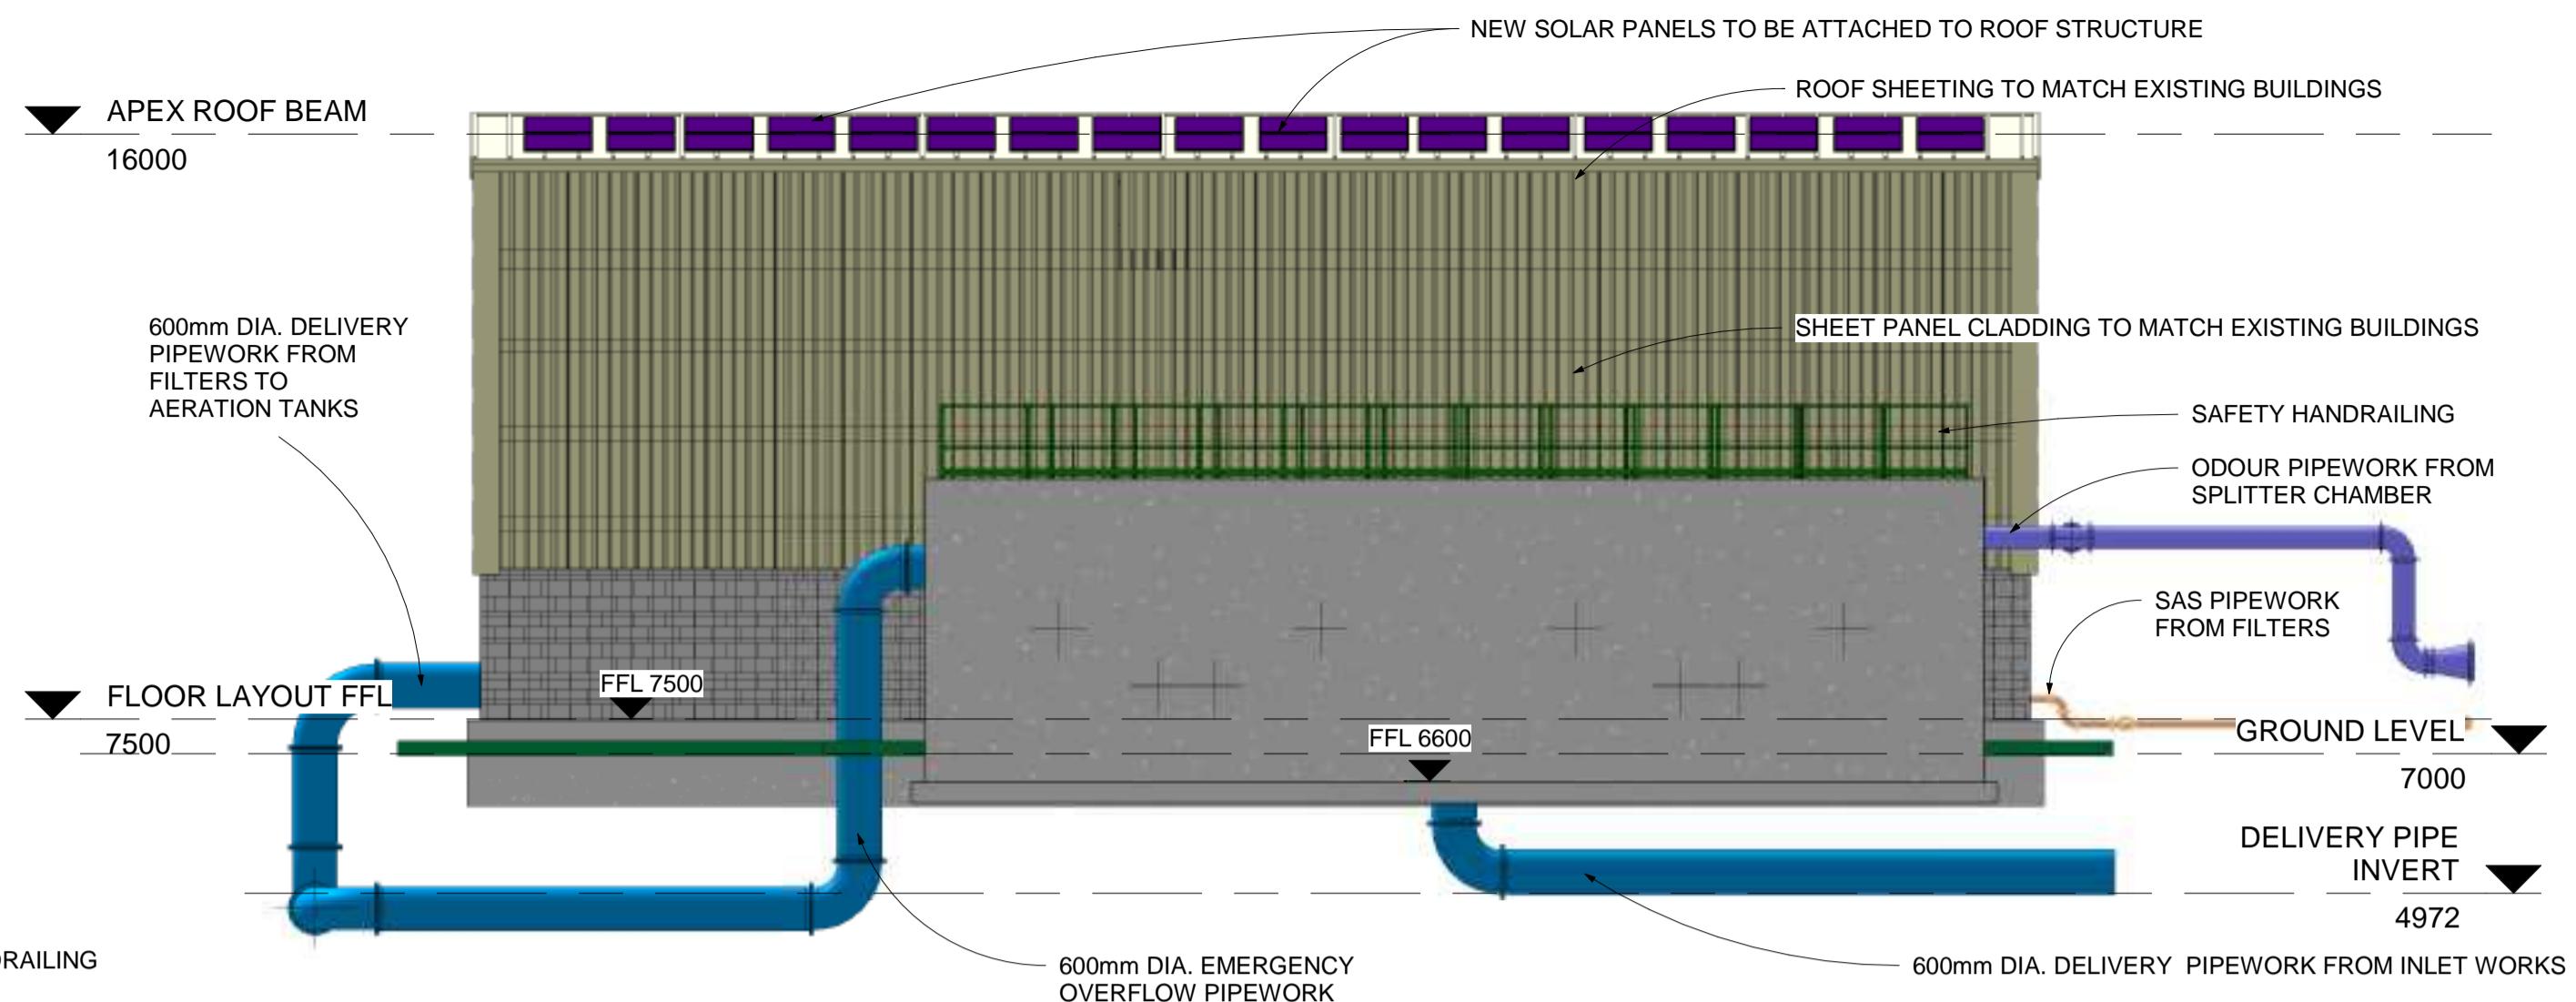


2 North Elevation
1 : 100

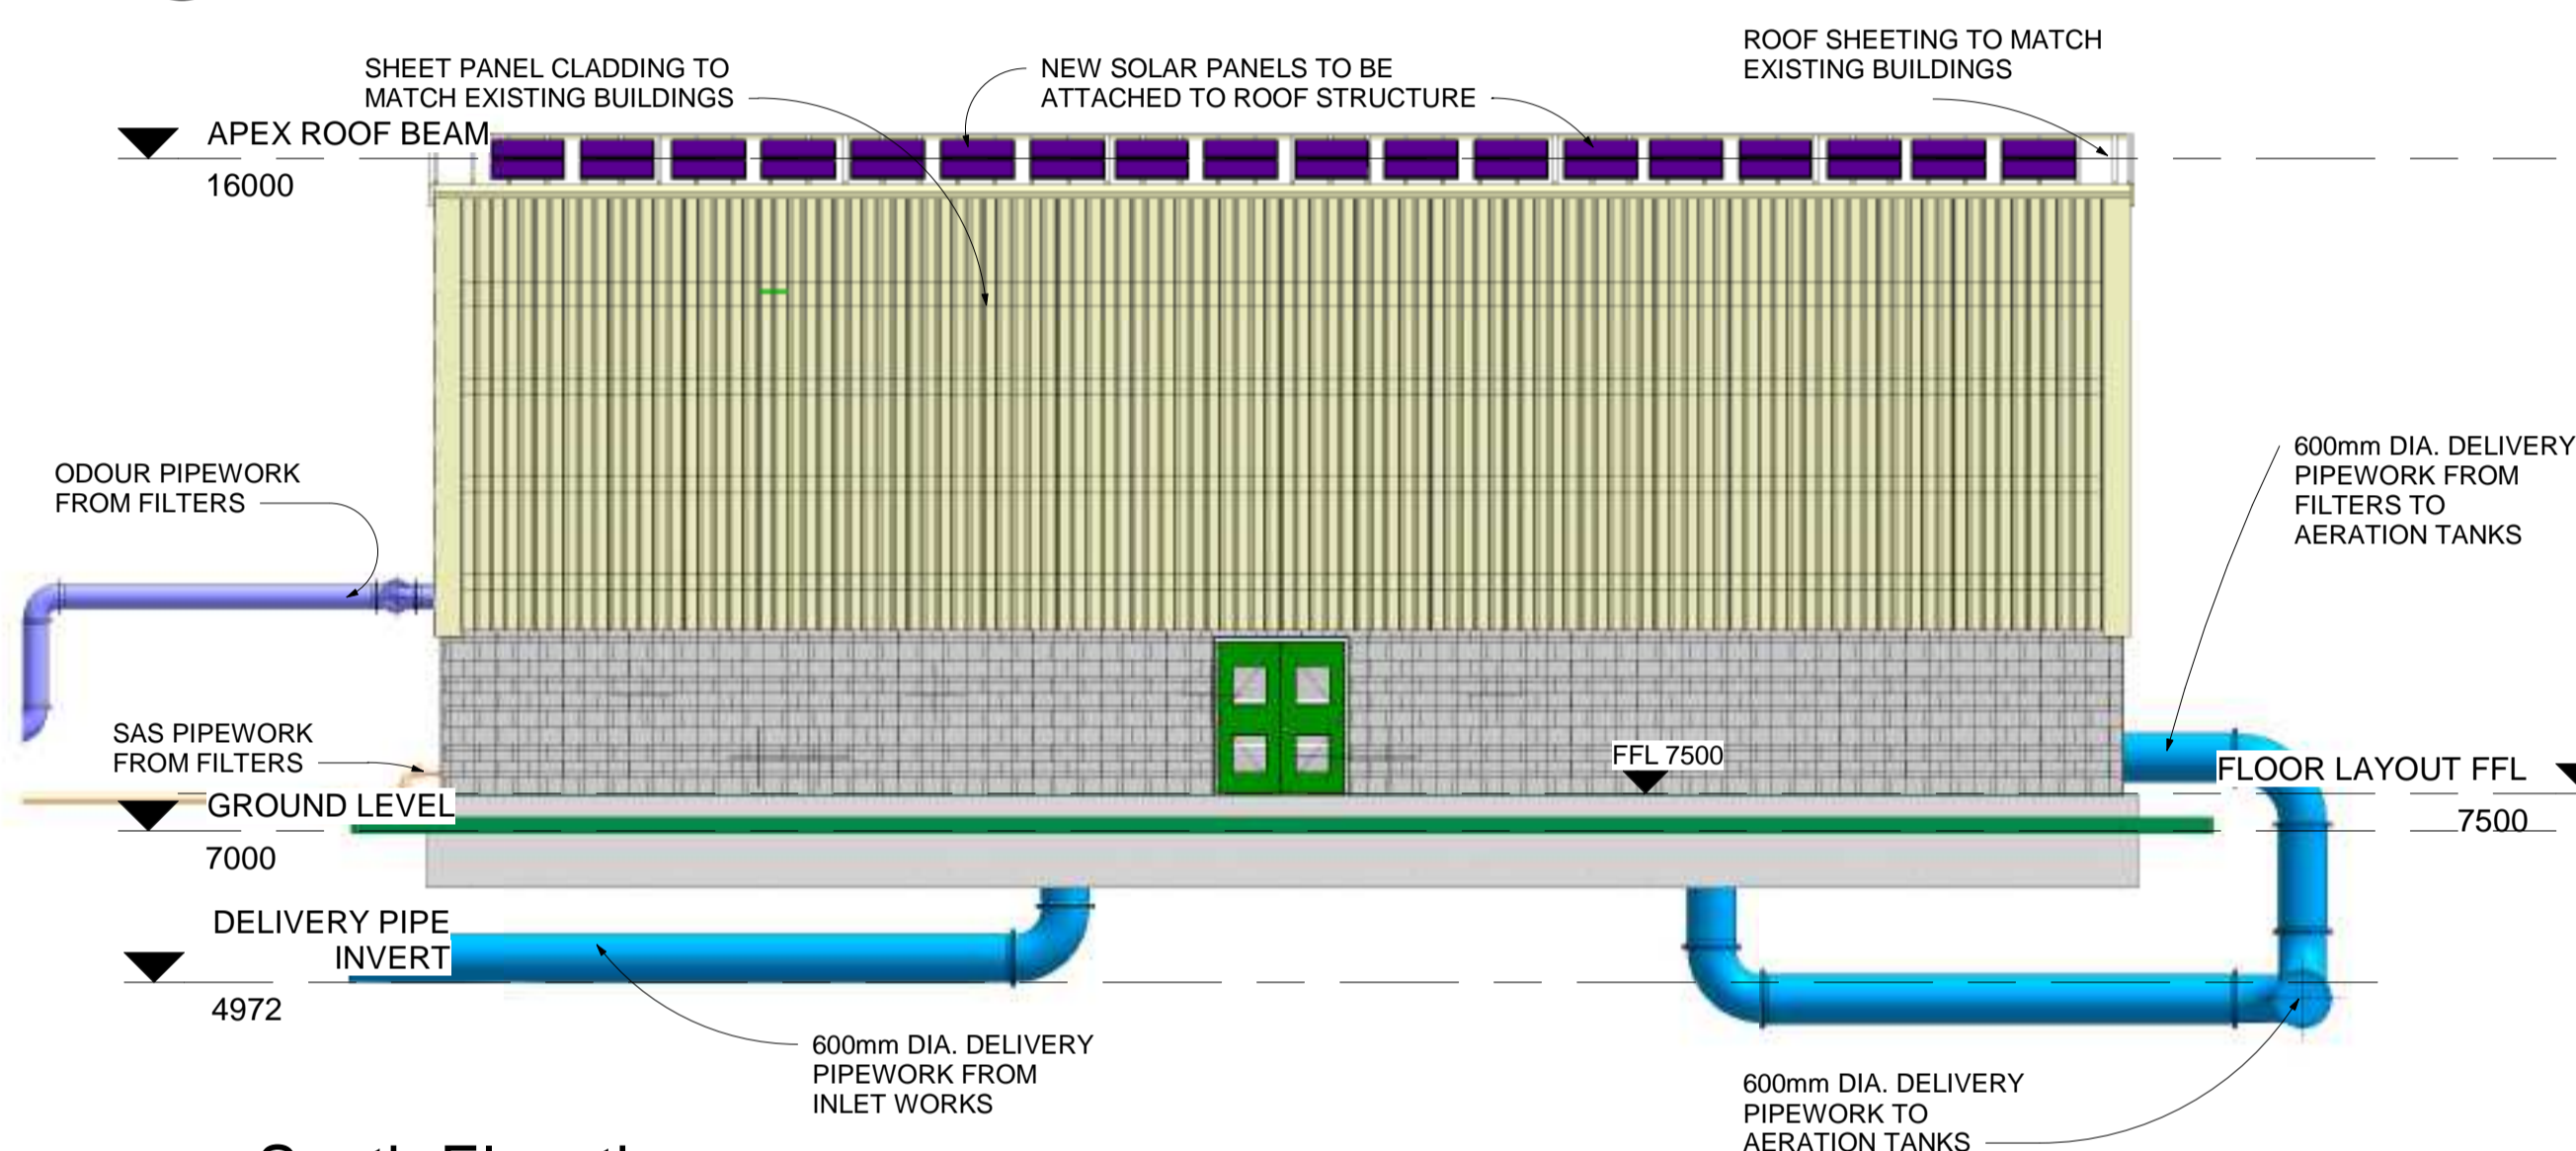

4 South Elevation
1 : 100

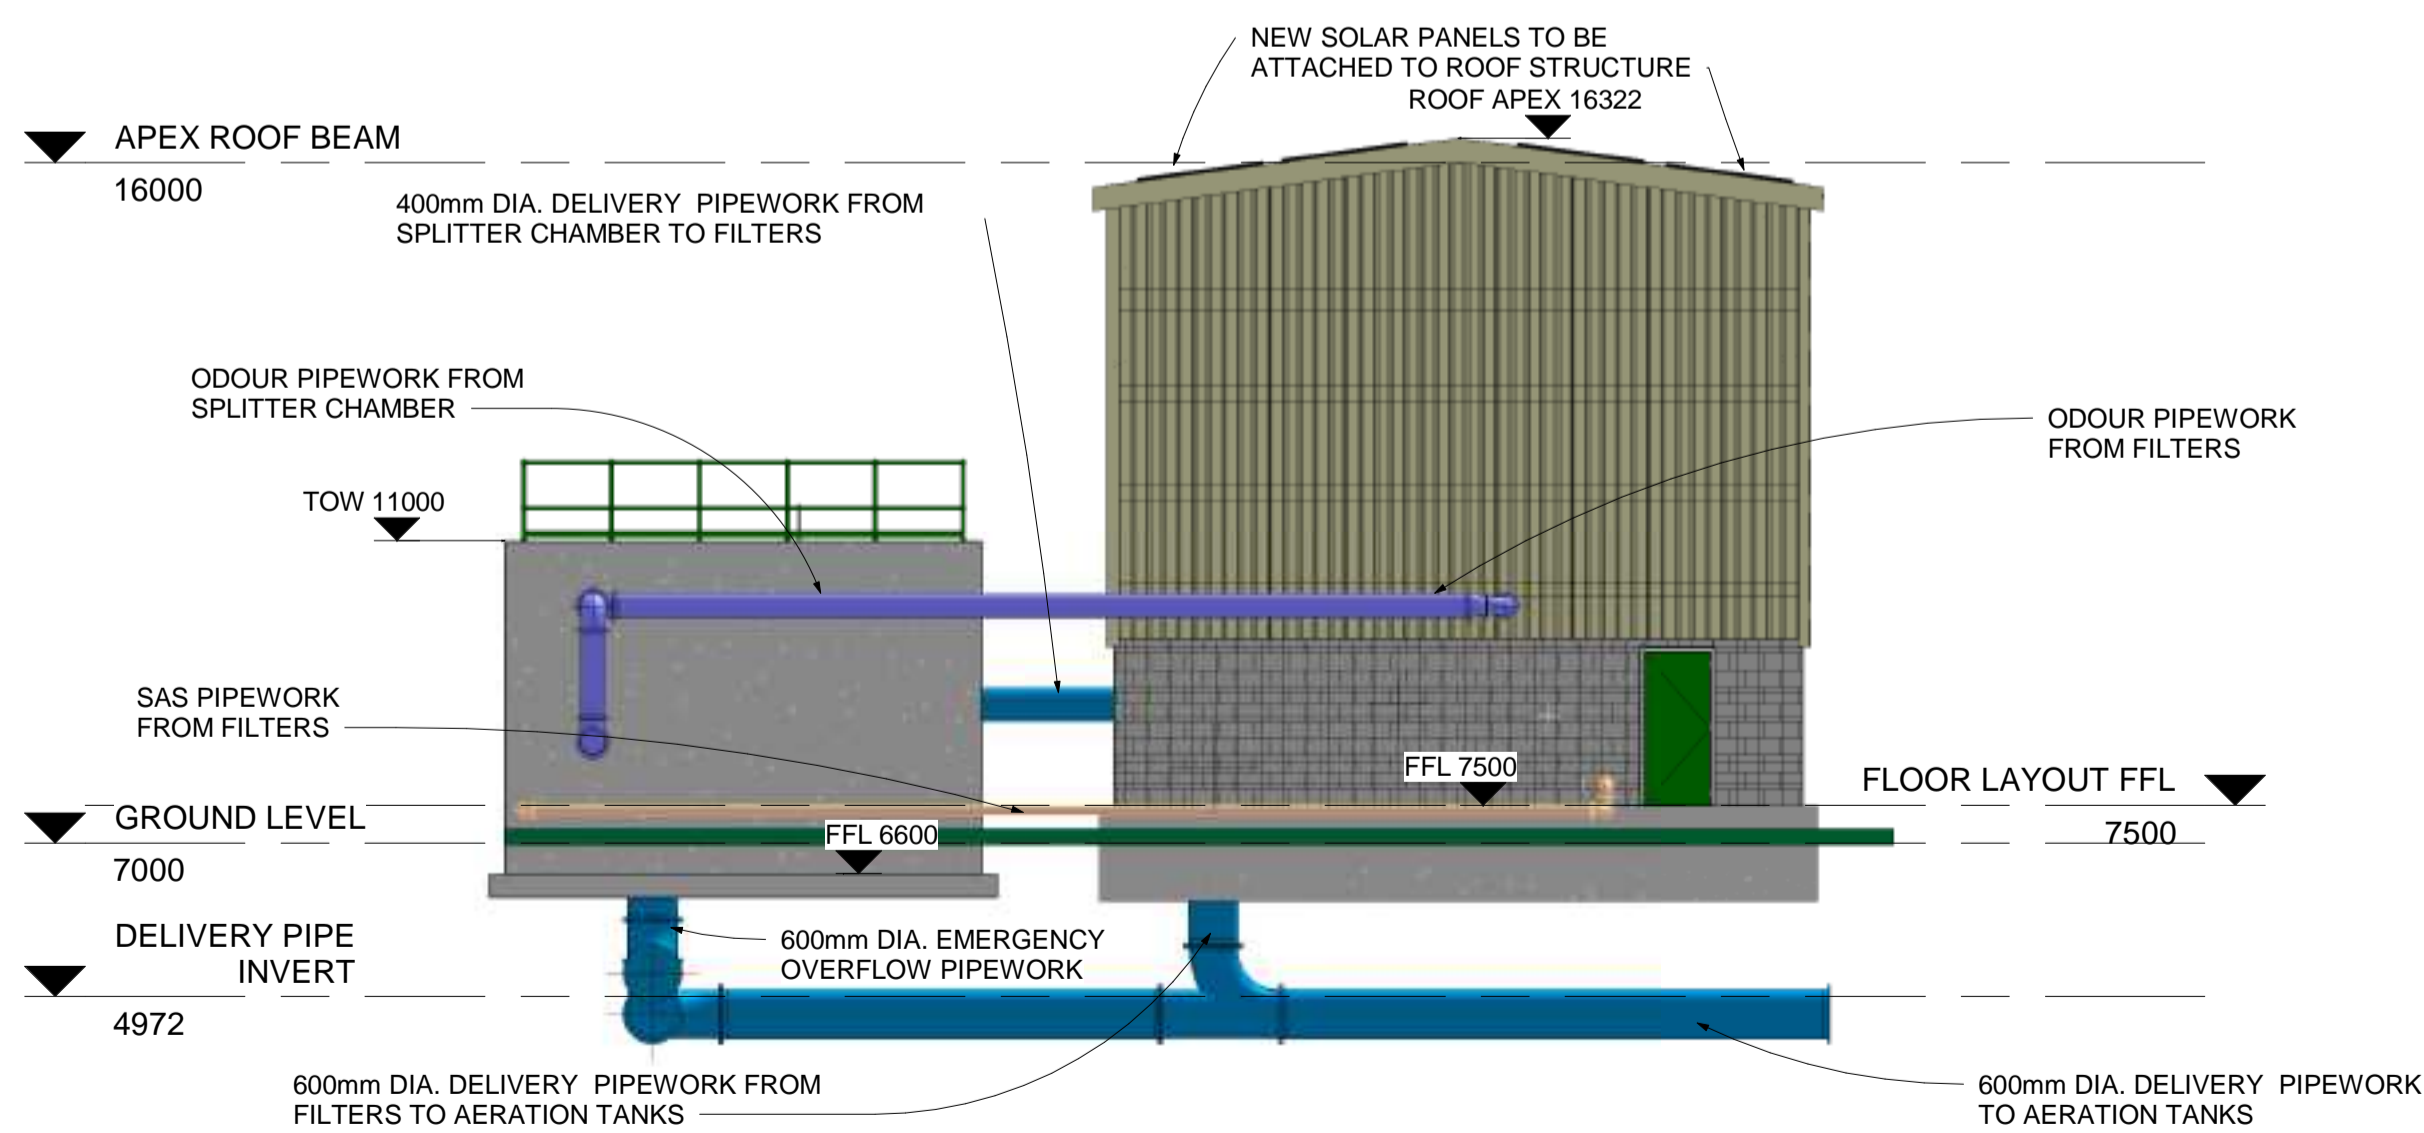

3 West Elevation
1 : 100

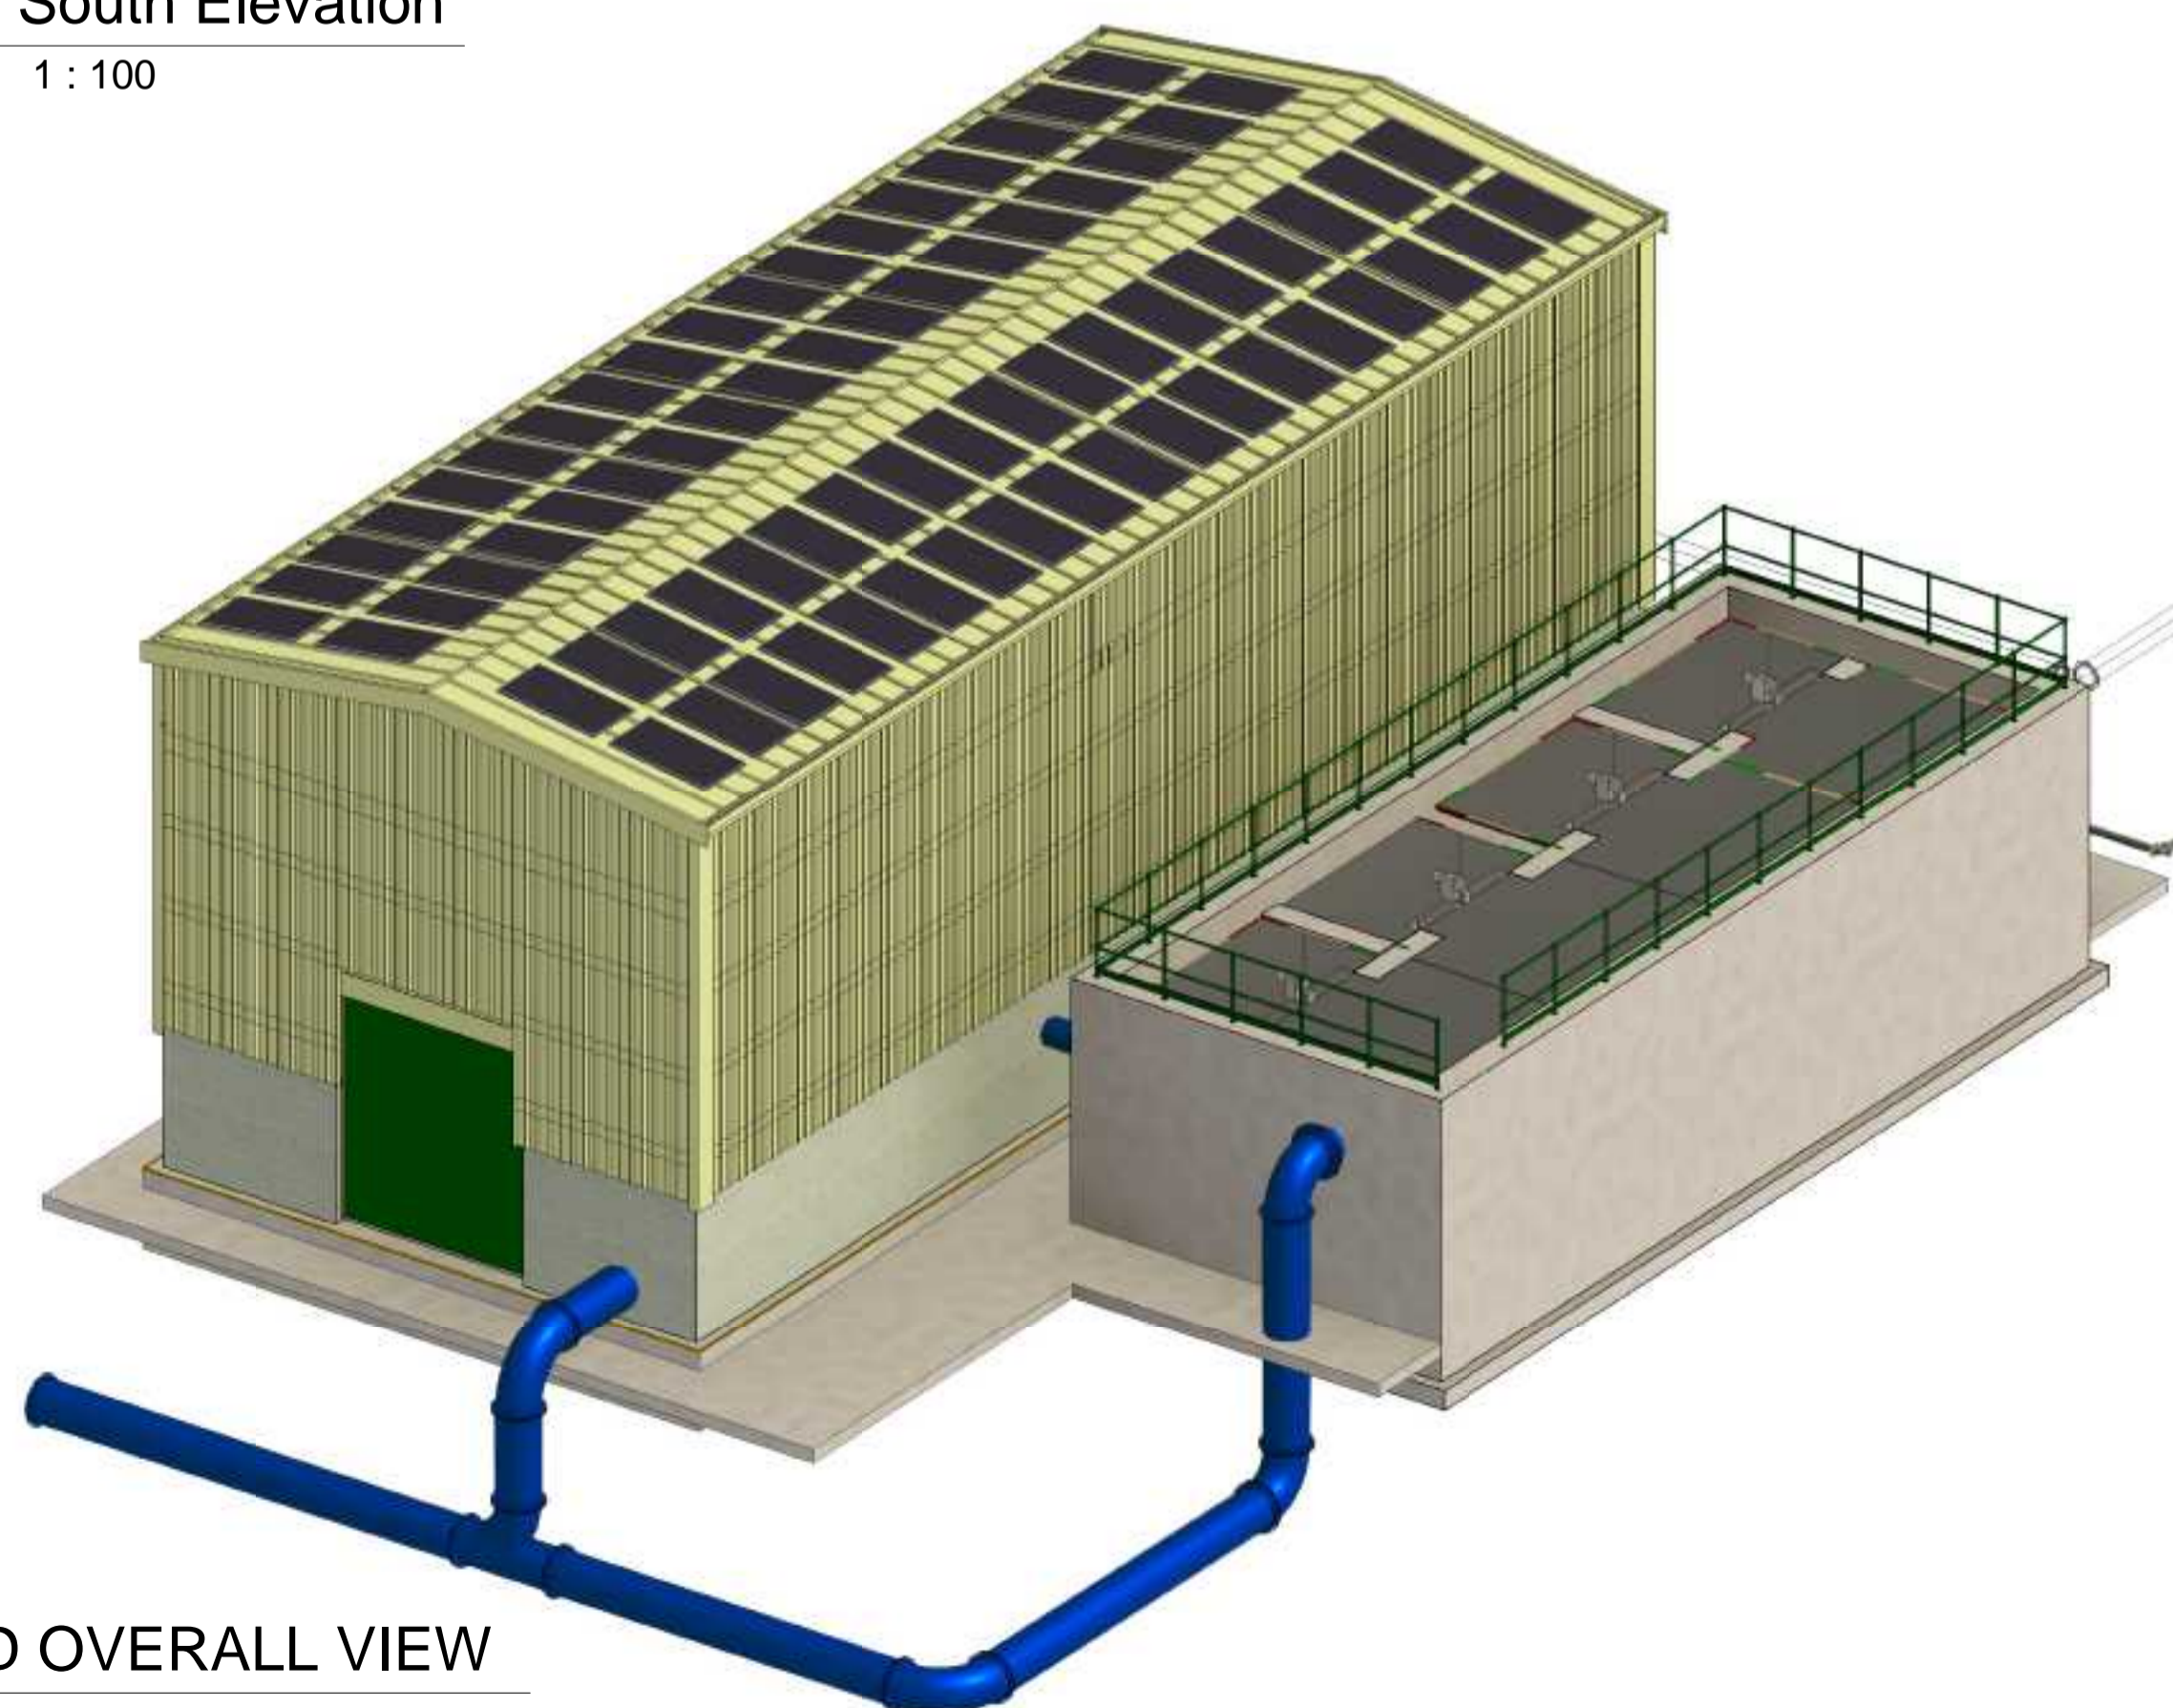

5 3D OVERALL VIEW

C01	A1	ISSUED FOR PLANNING	PJ	28-02-23
Rev:	Suit:	Revision Description	Checked:	Date:

Client:

Colville House
24-26 Talbot St
Dublin 1

Tel: 1890 278 278
Int: +353-1-707 2828
email: info@water.ie
Web: www.water.ie

Project:

CASTLETROY WASTEWATER TREATMENT PLANT

Clients Representative:

J. B. Barry and Partners Limited Consulting Engineers

Classon House
Dundrum Business Park
Dundrum Road
Dublin 14

Tel: +353 1 485 1400
email: info@jbbarry.ie
web: www.jbbarry.ie

Drawn By:	LA	Date:	03/21/22
Checked By:	PH	Date:	03/21/22
Approved by:	PJ	Date:	03/21/22
Internal Project No.	20701-JBB-00-XX-DR-Z	Stage	PLANNING

Drawing Title:

PROPOSED PRIMARY TREATMENT FILTER BUILDING AND SPLITTER CHAMBER ELEVATIONS

Scales: 1 : 100

Drawing No:	Sheet No:	Revision:	Suitability:
20701-JBB-00-XX-DR-Z	01007	C01	

O:\200 Projects\20701 - Castletroy WWTP (Case 2-4)00 WIP\Planning Drawings\Planning Drawings - FEB-2022\20701-JBB-00-XX-DR-Z\01005-01006-01007_Proposed Primary Filter, BLDG_Scheme_Chamber.rvt