

Copyright  
 This drawing and any design here on is the copyright of the Consultants and must not be reproduced without their written consent.  
 All drawings remain the property of the Consultants.

THIS DRAWING TO BE READ IN CONJUNCTION WITH ALL RELEVANT ARCHITECTS AND ENGINEERS DRAWINGS.

FIGURED DIMENSIONS ONLY TO BE TAKEN FROM THIS DRAWING.

ALL LEVELS ARE IN METRES AND RELATE TO DATUM AT MALIN HEAD.

THIS DRAWING IS REPRODUCED FROM DIGITAL MAPS:  
 O.S. MAPS - Scale 1:2,500  
 O.S. MAPS - Scale 1:1,000  
 DISCOVERY SERIES - Scale 1:50,000

ALL MAPS ARE REFERENCED TO IRISH NATIONAL GRID (I.T.M.)


REPRODUCED FROM THE ORDNANCE SURVEY OF IRELAND BY PERMISSION OF THE GOVERNMENT. LICENSE NO. 3-3-34.

THIS DRAWING IS A COPY OF AN ELECTRONIC FILE AND IS COPYRIGHT.


ALL DIMENSIONS TO BE CHECKED ON SITE.

ALL MATERIALS AND WORKMANSHIP TO BE IN ACCORDANCE WITH ENGINEERS SPECIFICATION.

IT IS THE CONTRACTORS RESPONSIBILITY TO VERIFY ALL DIMENSIONS AND LEVELS PRIOR TO COMMENCEMENT OF CONSTRUCTION.

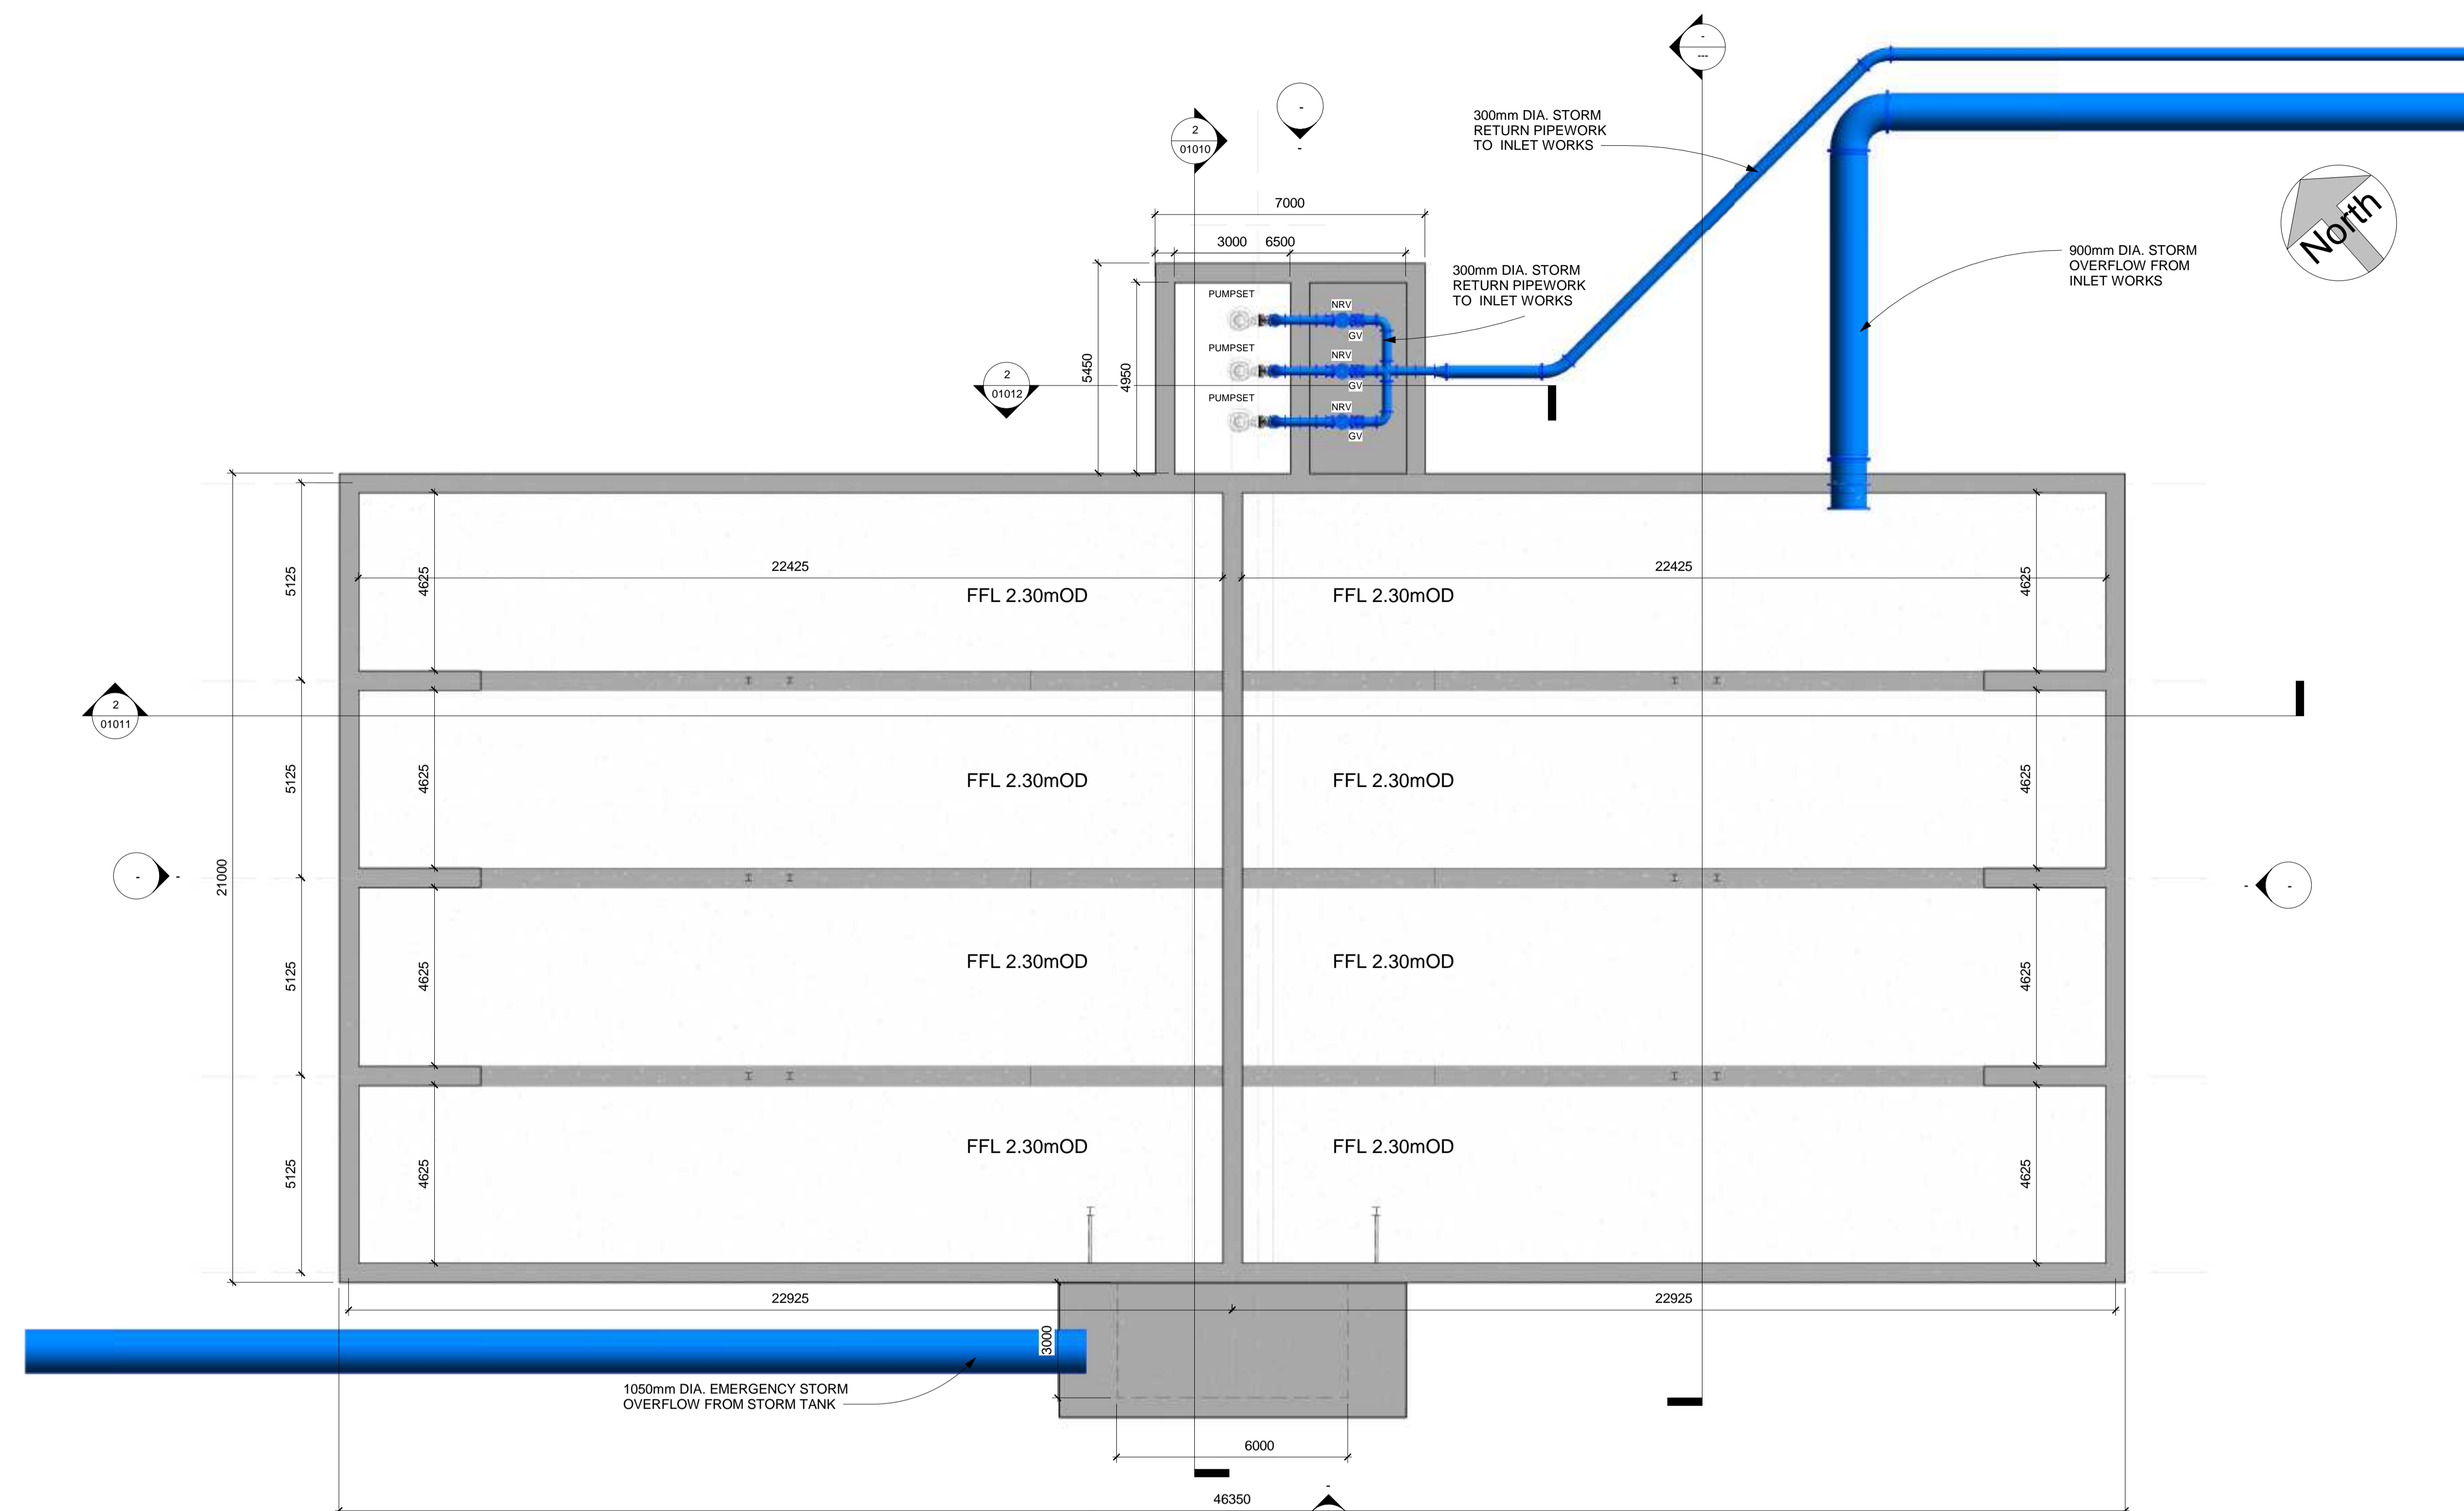

**1 Stormwater Storage Tank Floor Plan**  
 1 : 100

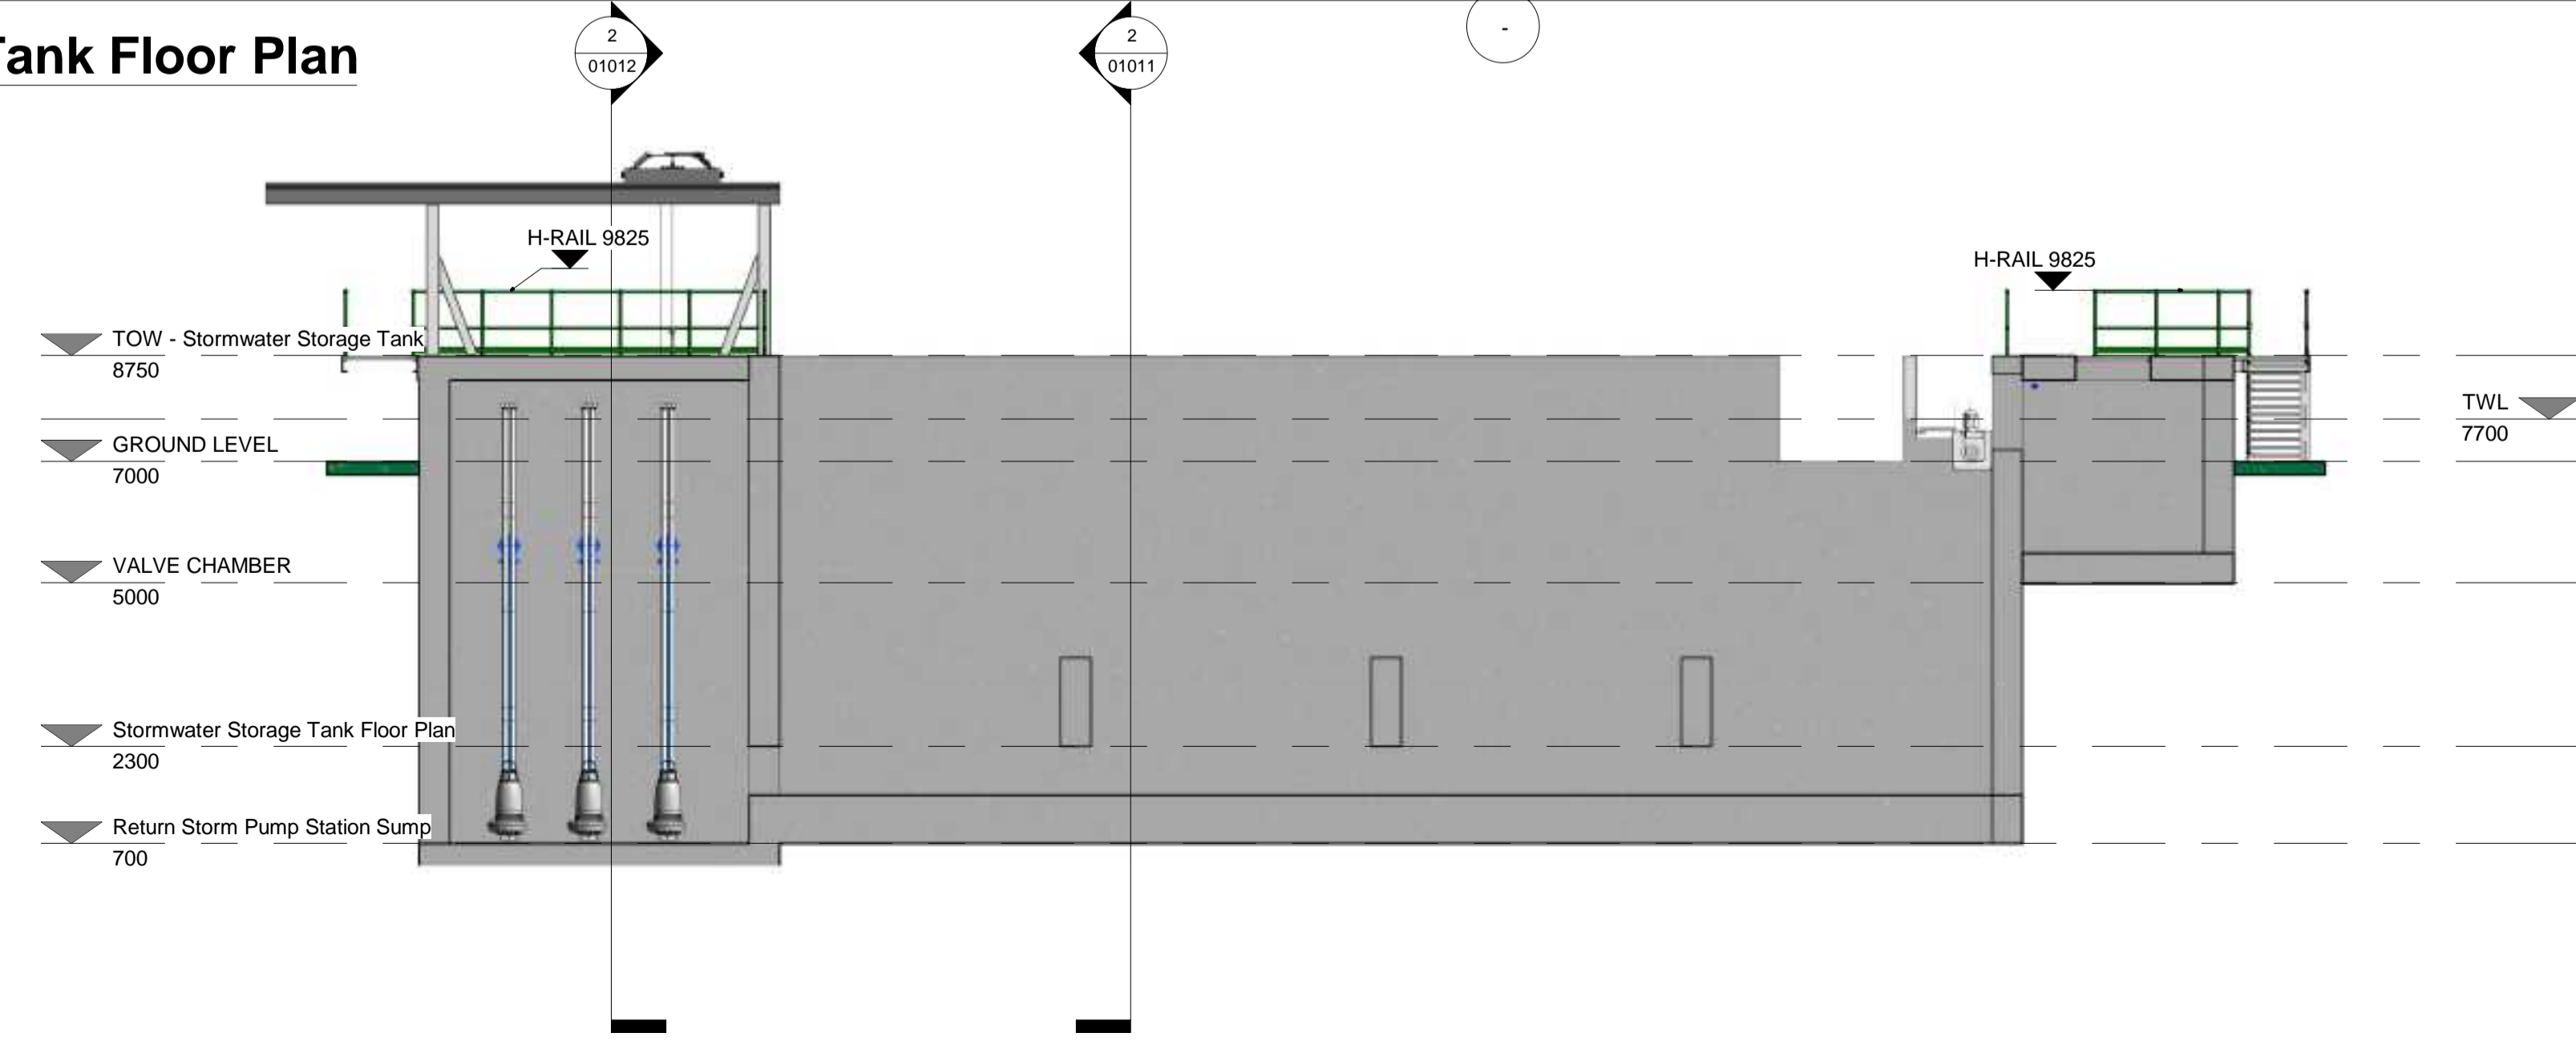

**2 Section 1**  
 1 : 100

C01	A1	ISSUED FOR PLANNING	PJ	28-02-23
Rev:	Suit:	Revision Description	Checked:	Date:

Client:

**UISCE**  
 EIREANN IRISH WATER

Colville House  
 24-26 Talbot St  
 Dublin 1

Tel: 1890 276 278  
 Int: +353-1-707 2828  
 email: info@uisce.ie  
 Web: www.water.ie

Project:

**CASTLETROY WASTEWATER TREATMENT PLANT**

Clients Representative:

**J. B. Barry and Partners Limited**  
 Consulting Engineers

Classon House  
 Dundrum Business Park  
 Dundrum Road  
 Dublin 14

Tel: +353 1 485 1400  
 email: info@jbbarry.ie  
 web: www.jbbarry.ie

Drawn By:	LA	Date:	06/12/22
Checked By:	PH	Date:	06/12/22
Approved by:	PJ	Date:	06/12/22
Internal Project No.	20701-JBB-00-XX-DR-Z	Stage	PLANNING

Drawing Title:

**PROPOSED STORMWATER STORAGE TANK AND RETURN PUMP STATION PLAN AND SECTION**

Scales: 1 : 100

Drawing No:	Sheet No:	Revision:	Suitability:
20701-JBB-00-XX-DR-Z	01010	C01	

O:20 Projects\20701 - Castletroy WwTP (Case 2-4100-WPP\Planning Drawings\Planning Drawings\FEB-2023\20701-JBB-00-XX-DR-Z-01010-01012-01013-Proposed Stormwater Storage Tank and Return Pump Station.rvt