

Copyright  
 This drawing and any design here on is the copyright of the Consultants and must not be reproduced without their written consent. All drawings remain the property of the Consultants.

THIS DRAWING TO BE READ IN CONJUNCTION WITH ALL RELEVANT ARCHITECTS AND ENGINEERS DRAWINGS.

FIGURED DIMENSIONS ONLY TO BE TAKEN FROM THIS DRAWING.

ALL LEVELS ARE IN METRES AND RELATE TO DATUM AT MALIN HEAD.

THIS DRAWING IS REPRODUCED FROM DIGITAL MAPS:  
 O.S. MAPS - Scale 1:2,500  
 O.S. MAPS - Scale 1:1,000  
 DISCOVERY SERIES - Scale 1:50,000

ALL MAPS ARE REFERENCED TO IRISH NATIONAL GRID (I.T.M.)


REPRODUCED FROM THE ORDNANCE SURVEY OF IRELAND BY PERMISSION OF THE GOVERNMENT. LICENSE NO. 3-3-34.

THIS DRAWING IS A COPY OF AN ELECTRONIC FILE AND IS COPYRIGHT.


ALL DIMENSIONS TO BE CHECKED ON SITE.

ALL MATERIALS AND WORKMANSHIP TO BE IN ACCORDANCE WITH ENGINEERS SPECIFICATION.


IT IS THE CONTRACTORS RESPONSIBILITY TO VERIFY ALL DIMENSIONS AND LEVELS PRIOR TO COMMENCEMENT OF CONSTRUCTION.

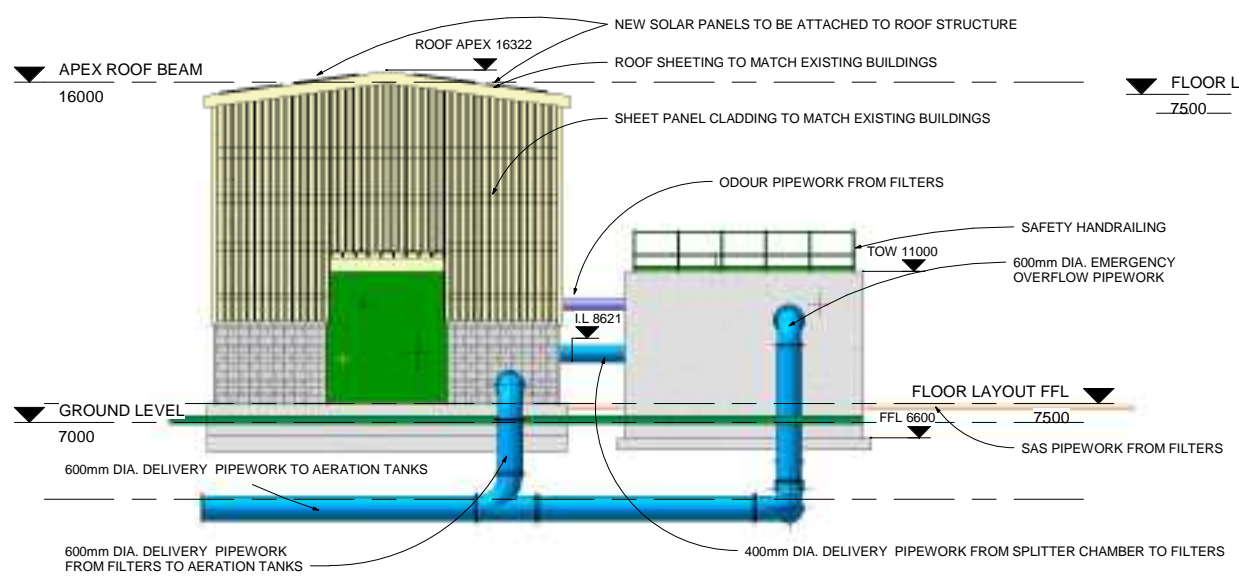


1 East Elevation  
 1 : 100

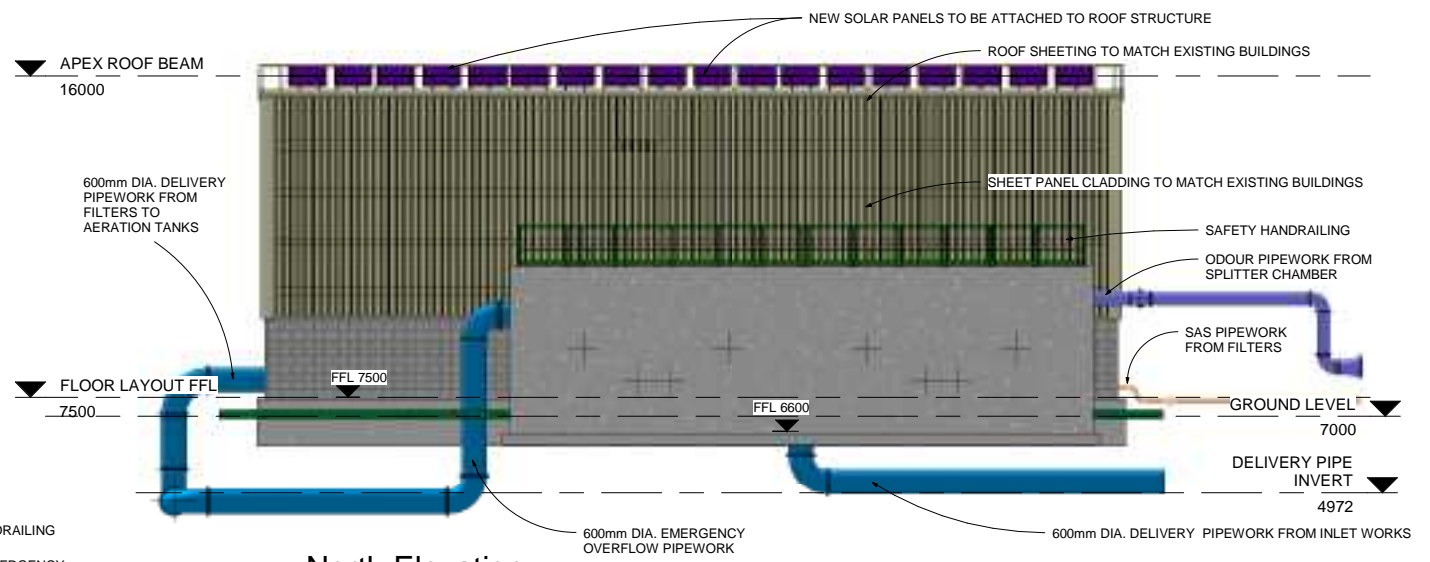


2 North Elevation  
 1 : 100

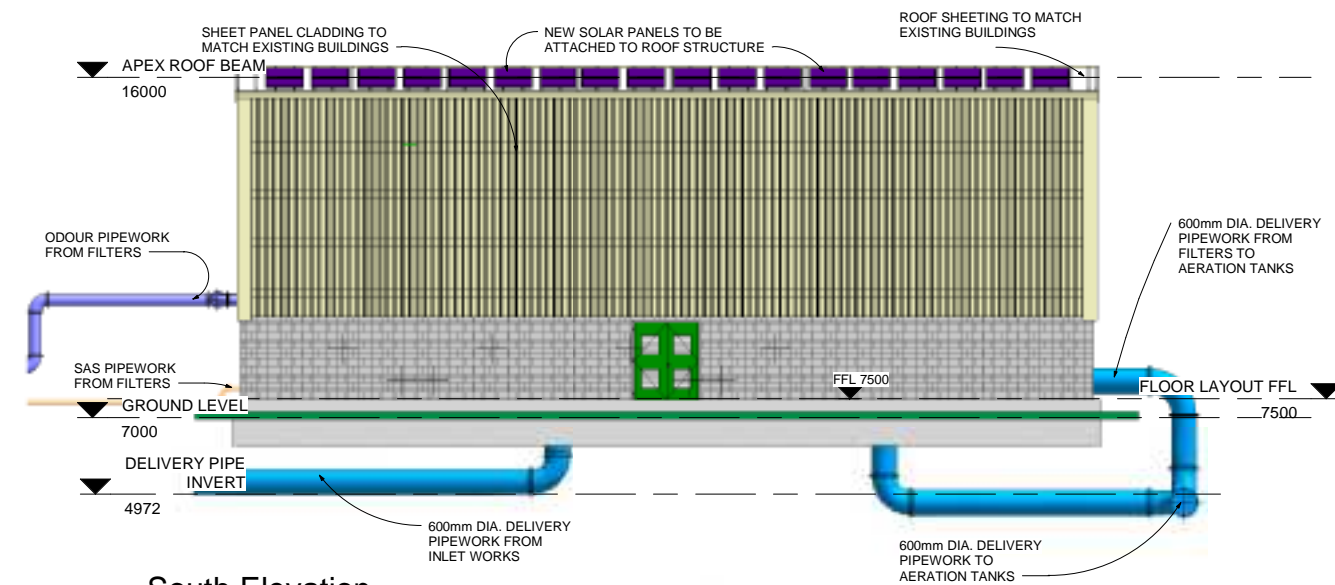

4 South Elevation  
 1 : 100

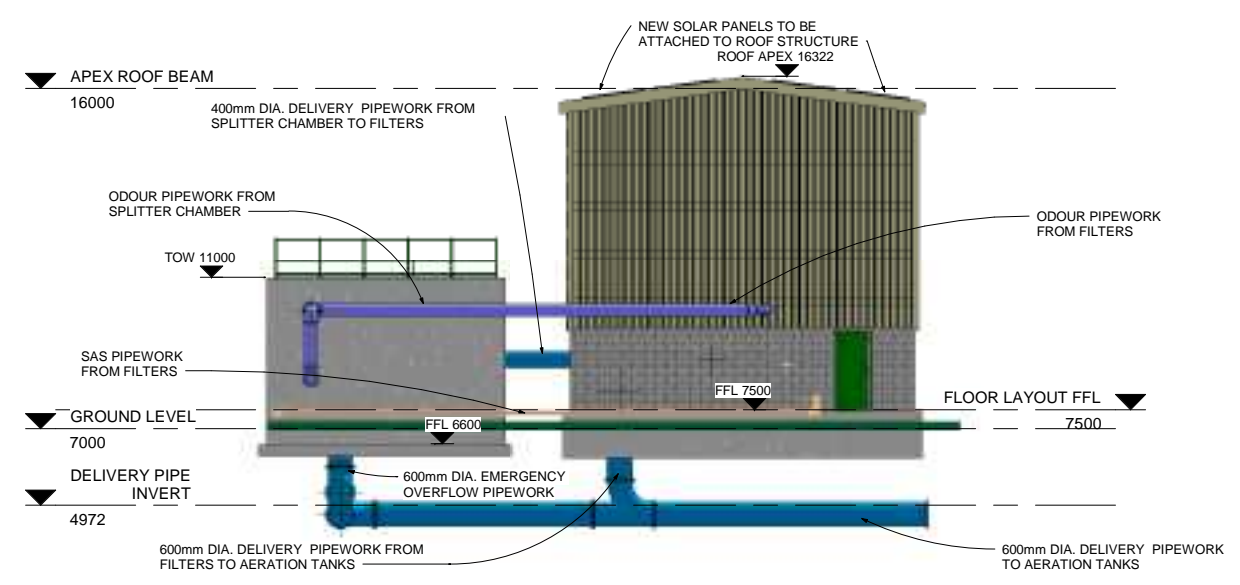

3 West Elevation  
 1 : 100

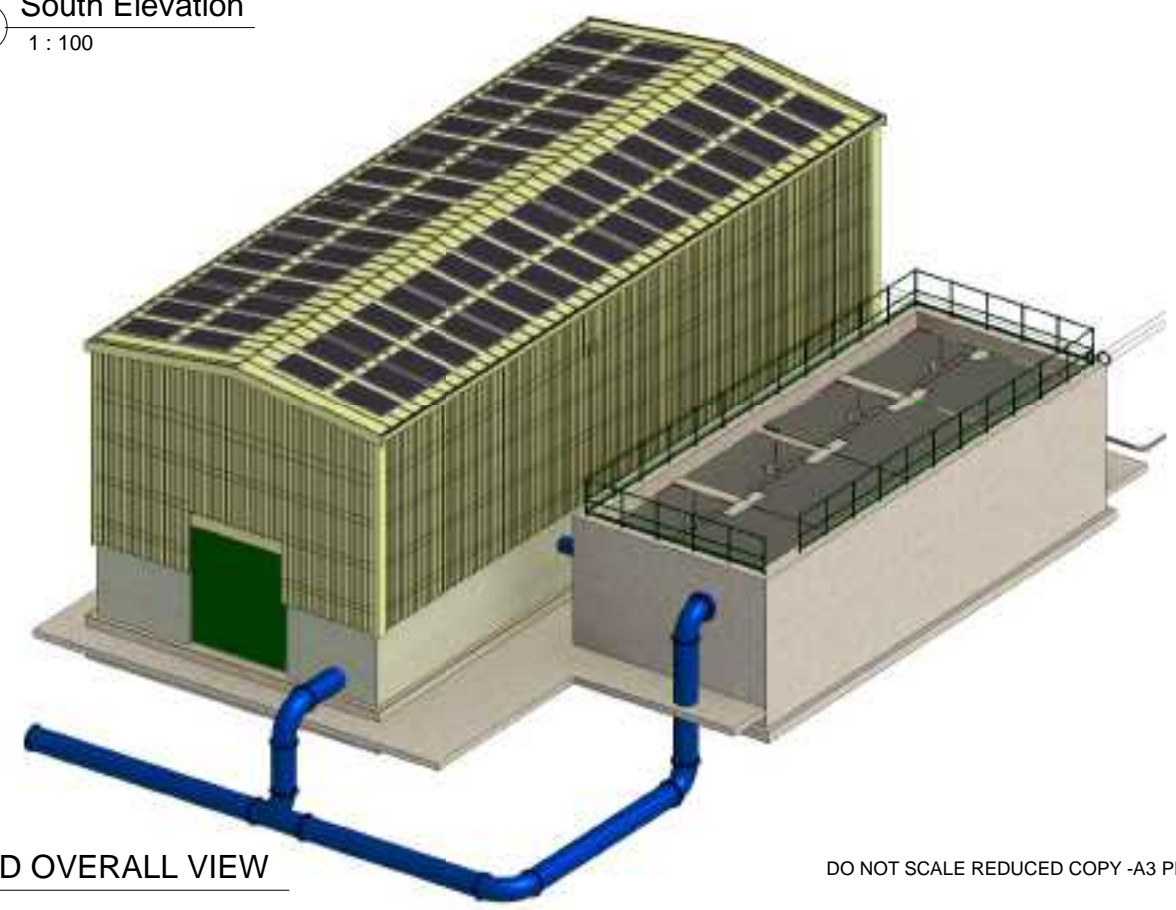

5 3D OVERALL VIEW

DO NOT SCALE REDUCED COPY -A3 PRINT


C01	A1	ISSUED FOR EIA/R	PJ	28-02-23
Rev:	Suit:	Revision Description	Checked:	Date:

Client:

Project:

**CASTLETROY WASTEWATER TREATMENT PLANT**

Clients Representative:

**J. B. Barry and Partners Limited**  
 Consulting Engineers

Classon House  
 Dundrum Business Park  
 Dundrum Road  
 Dublin 14

Tel: +353 1 485 1400  
 email: info@jbbarry.ie  
 web: www.jbbarry.ie

Drawn By:	LA	Date:	03/21/22
Checked By:	PH	Date:	03/21/22
Approved by:	PJ	Date:	03/21/22
Internal Project No.	20701-JBB-00-XX-DR-Z	Stage	EIA/R

Drawing Title:

**PROPOSED PRIMARY TREATMENT FILTER BUILDING AND SPLITTER CHAMBER ELEVATIONS**

Scales:	1 : 100						
Drawing No:	20701-JBB-00-XX-DR-Z	Sheet No:	01007	Revision:	C01	Suitability:	

0:20 Project:20701 - Castletroy WWTTP (Scale 2:4:100)WP:DWG:EIA/R Drawings:March 2023:20701-JBB-00-XX-DR-Z:01006-01006-01007 - Proposed Primary Filter, BLDG, Splitter Chamber.rvt