

Copyright
 This drawing and any design here on is the copyright of the Consultants and must not be reproduced without their written consent. All drawings remain the property of the Consultants.

THIS DRAWING TO BE READ IN CONJUNCTION WITH ALL RELEVANT ARCHITECTS AND ENGINEERS DRAWINGS.

FIGURED DIMENSIONS ONLY TO BE TAKEN FROM THIS DRAWING.

ALL LEVELS ARE IN METRES AND RELATE TO DATUM AT MALIN HEAD.

THIS DRAWING IS REPRODUCED FROM DIGITAL MAPS:
 O.S. MAPS - Scale 1:2,500
 O.S. MAPS - Scale 1:1,000
 DISCOVERY SERIES - Scale 1:50,000

ALL MAPS ARE REFERENCED TO IRISH NATIONAL GRID (I.T.M.)


REPRODUCED FROM THE ORDNANCE SURVEY OF IRELAND BY PERMISSION OF THE GOVERNMENT. LICENSE NO. 3-3-34.

THIS DRAWING IS A COPY OF AN ELECTRONIC FILE AND IS COPYRIGHT.


ALL DIMENSIONS TO BE CHECKED ON SITE.

ALL MATERIALS AND WORKMANSHIP TO BE IN ACCORDANCE WITH ENGINEERS SPECIFICATION.

IT IS THE CONTRACTORS RESPONSIBILITY TO VERIFY ALL DIMENSIONS AND LEVELS PRIOR TO COMMENCEMENT OF CONSTRUCTION.

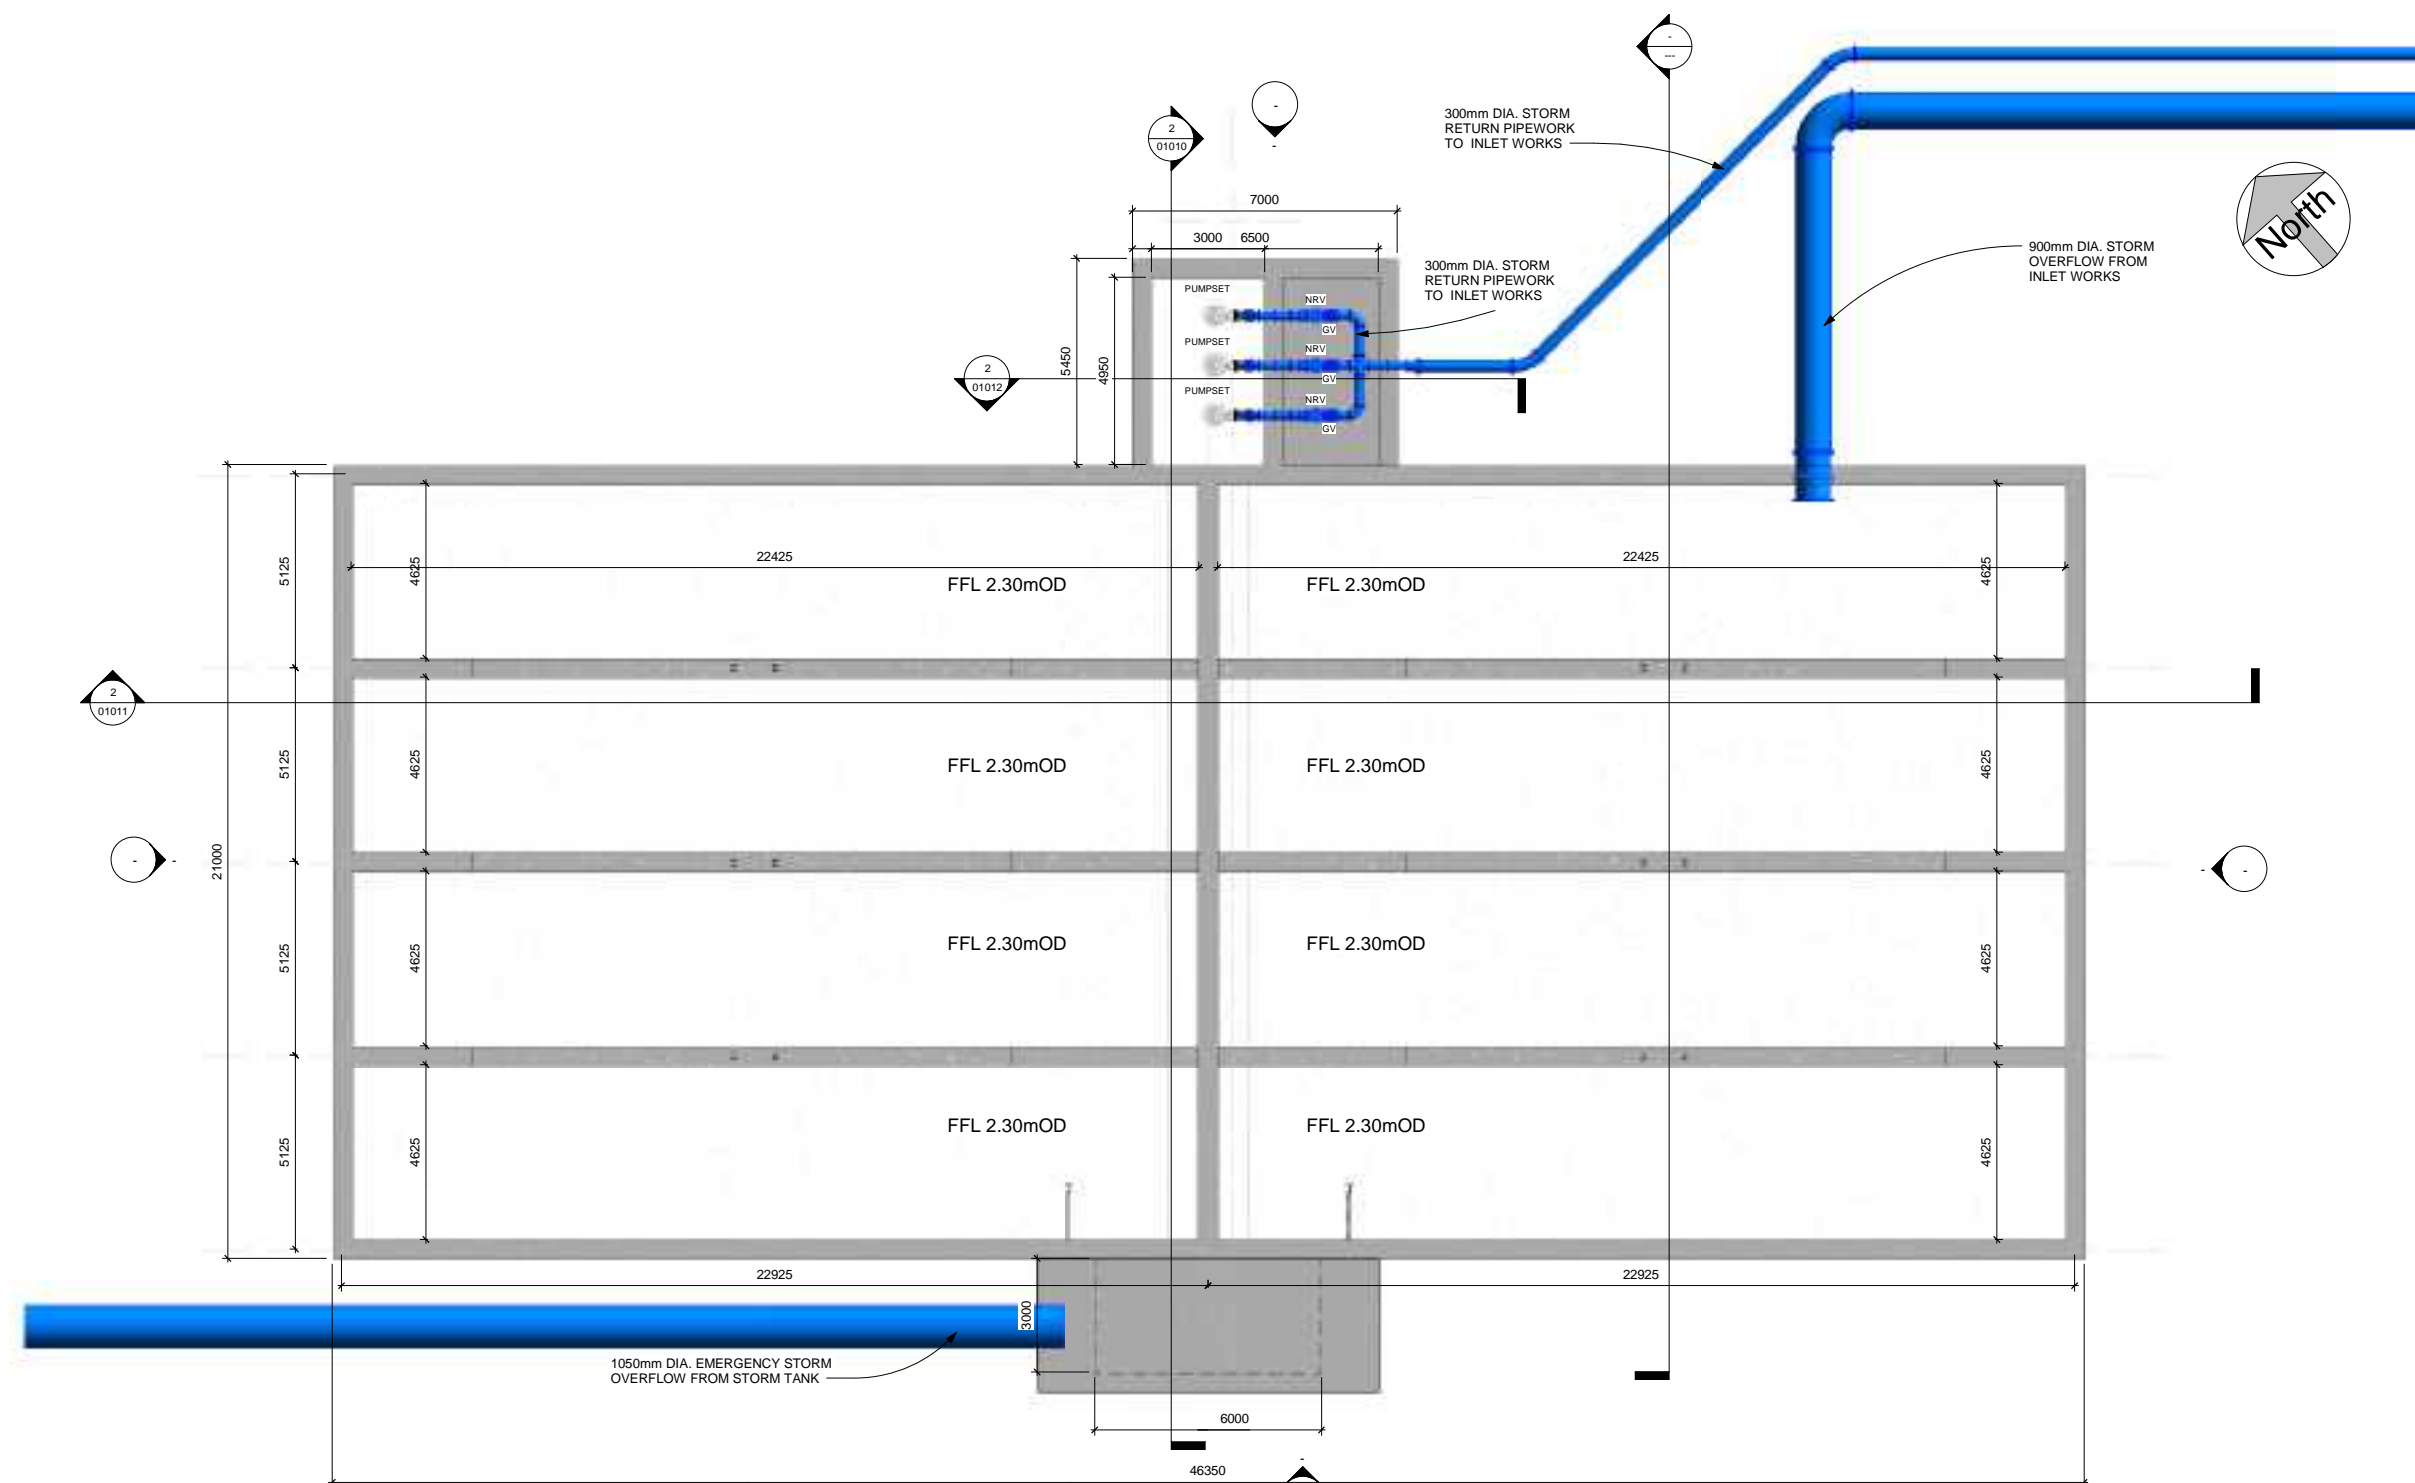

1 Stormwater Storage Tank Floor Plan
 1 : 100

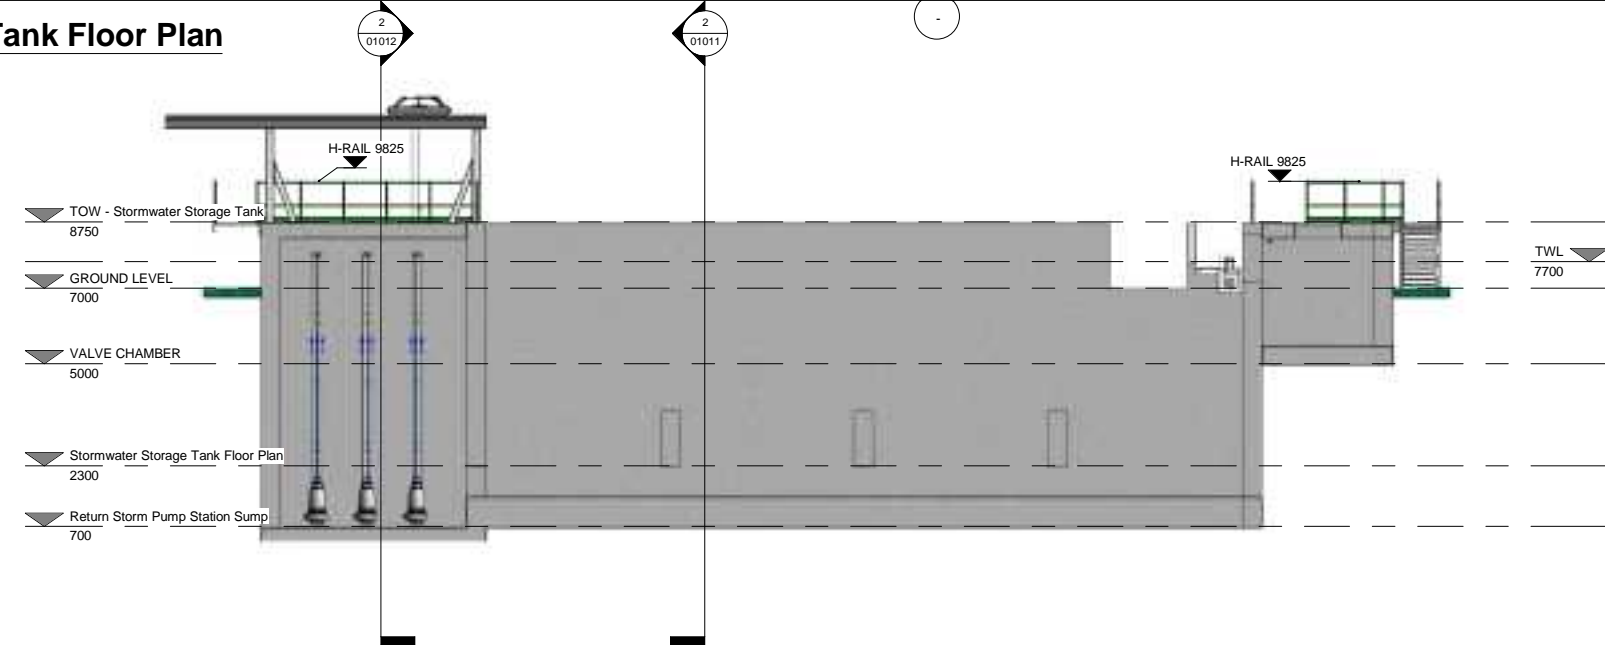

2 Section 1
 1 : 100

DO NOT SCALE REDUCED COPY -A3 PRINT

C01 A1 ISSUED FOR EIA/				PJ	28-02-23
Rev:	Suit:	Revision Description	Checked:	Date:	
Client:					
Project:					
CASTLETROY WASTEWATER TREATMENT PLANT					
Clients Representative:					
J. B. Barry and Partners Limited Consulting Engineers Classon House Tel: +353 1 485 1400 Dundrum Business email: info@jbbarry.ie Park Dundrum Road web: www.jbbarry.ie Dublin 14					
Drawn By:	LA	Date:	06/12/22		
Checked By:	PH	Date:	06/12/22		
Approved by:	PJ	Date:	06/12/22		
Internal Project No.	20701-JBB-00-XX-DR-Z	Stage	EIA/		
Drawing Title:					
PROPOSED STORMWATER STORAGE TANK AND RETURN PUMP STATION PLAN AND SECTION					
Scales: 1 : 100					
Drawing No:	Sheet No:	Revision:	Suitability:		
20701-JBB-00-XX-DR-Z	01010	C01			

O:\20 Project\20701 - Castletroy WWTTP - Castle 2-400-WP-Dwg\EIA/DR-Z-01010-01011-01012-01013-Proposed Stormwater Storage Tank and Return Pump Station.dwg