



NOTE: CONFIDENTIAL, NO THIRD PARTY DISCLOSURE ALLOWED.
 All rights reserved.
 © J.B. Barry and Partners
 T.J. O'Connor and Associates
 Royal Haskoning DHV 2014

1. All levels are in metres and relate to O.S. Datum MALIN.
 2. This drawing is reproduced from digital maps:
 O.S. MAPS - Scale 1:2,500
 O.S. MAPS - Scale 1:1,000
 Discovery Series - Scale 1:50,000
 3. All Maps are referenced to IRISH NATIONAL GRID (I.T.M.)
 4. Reproduced from the Ordnance Survey of Ireland by Permission of the Government. License No. 3-3-34.


NOTES
 1. No Structural changes required to existing building.
 2. UV lamps modules to be replaced within existing channels.

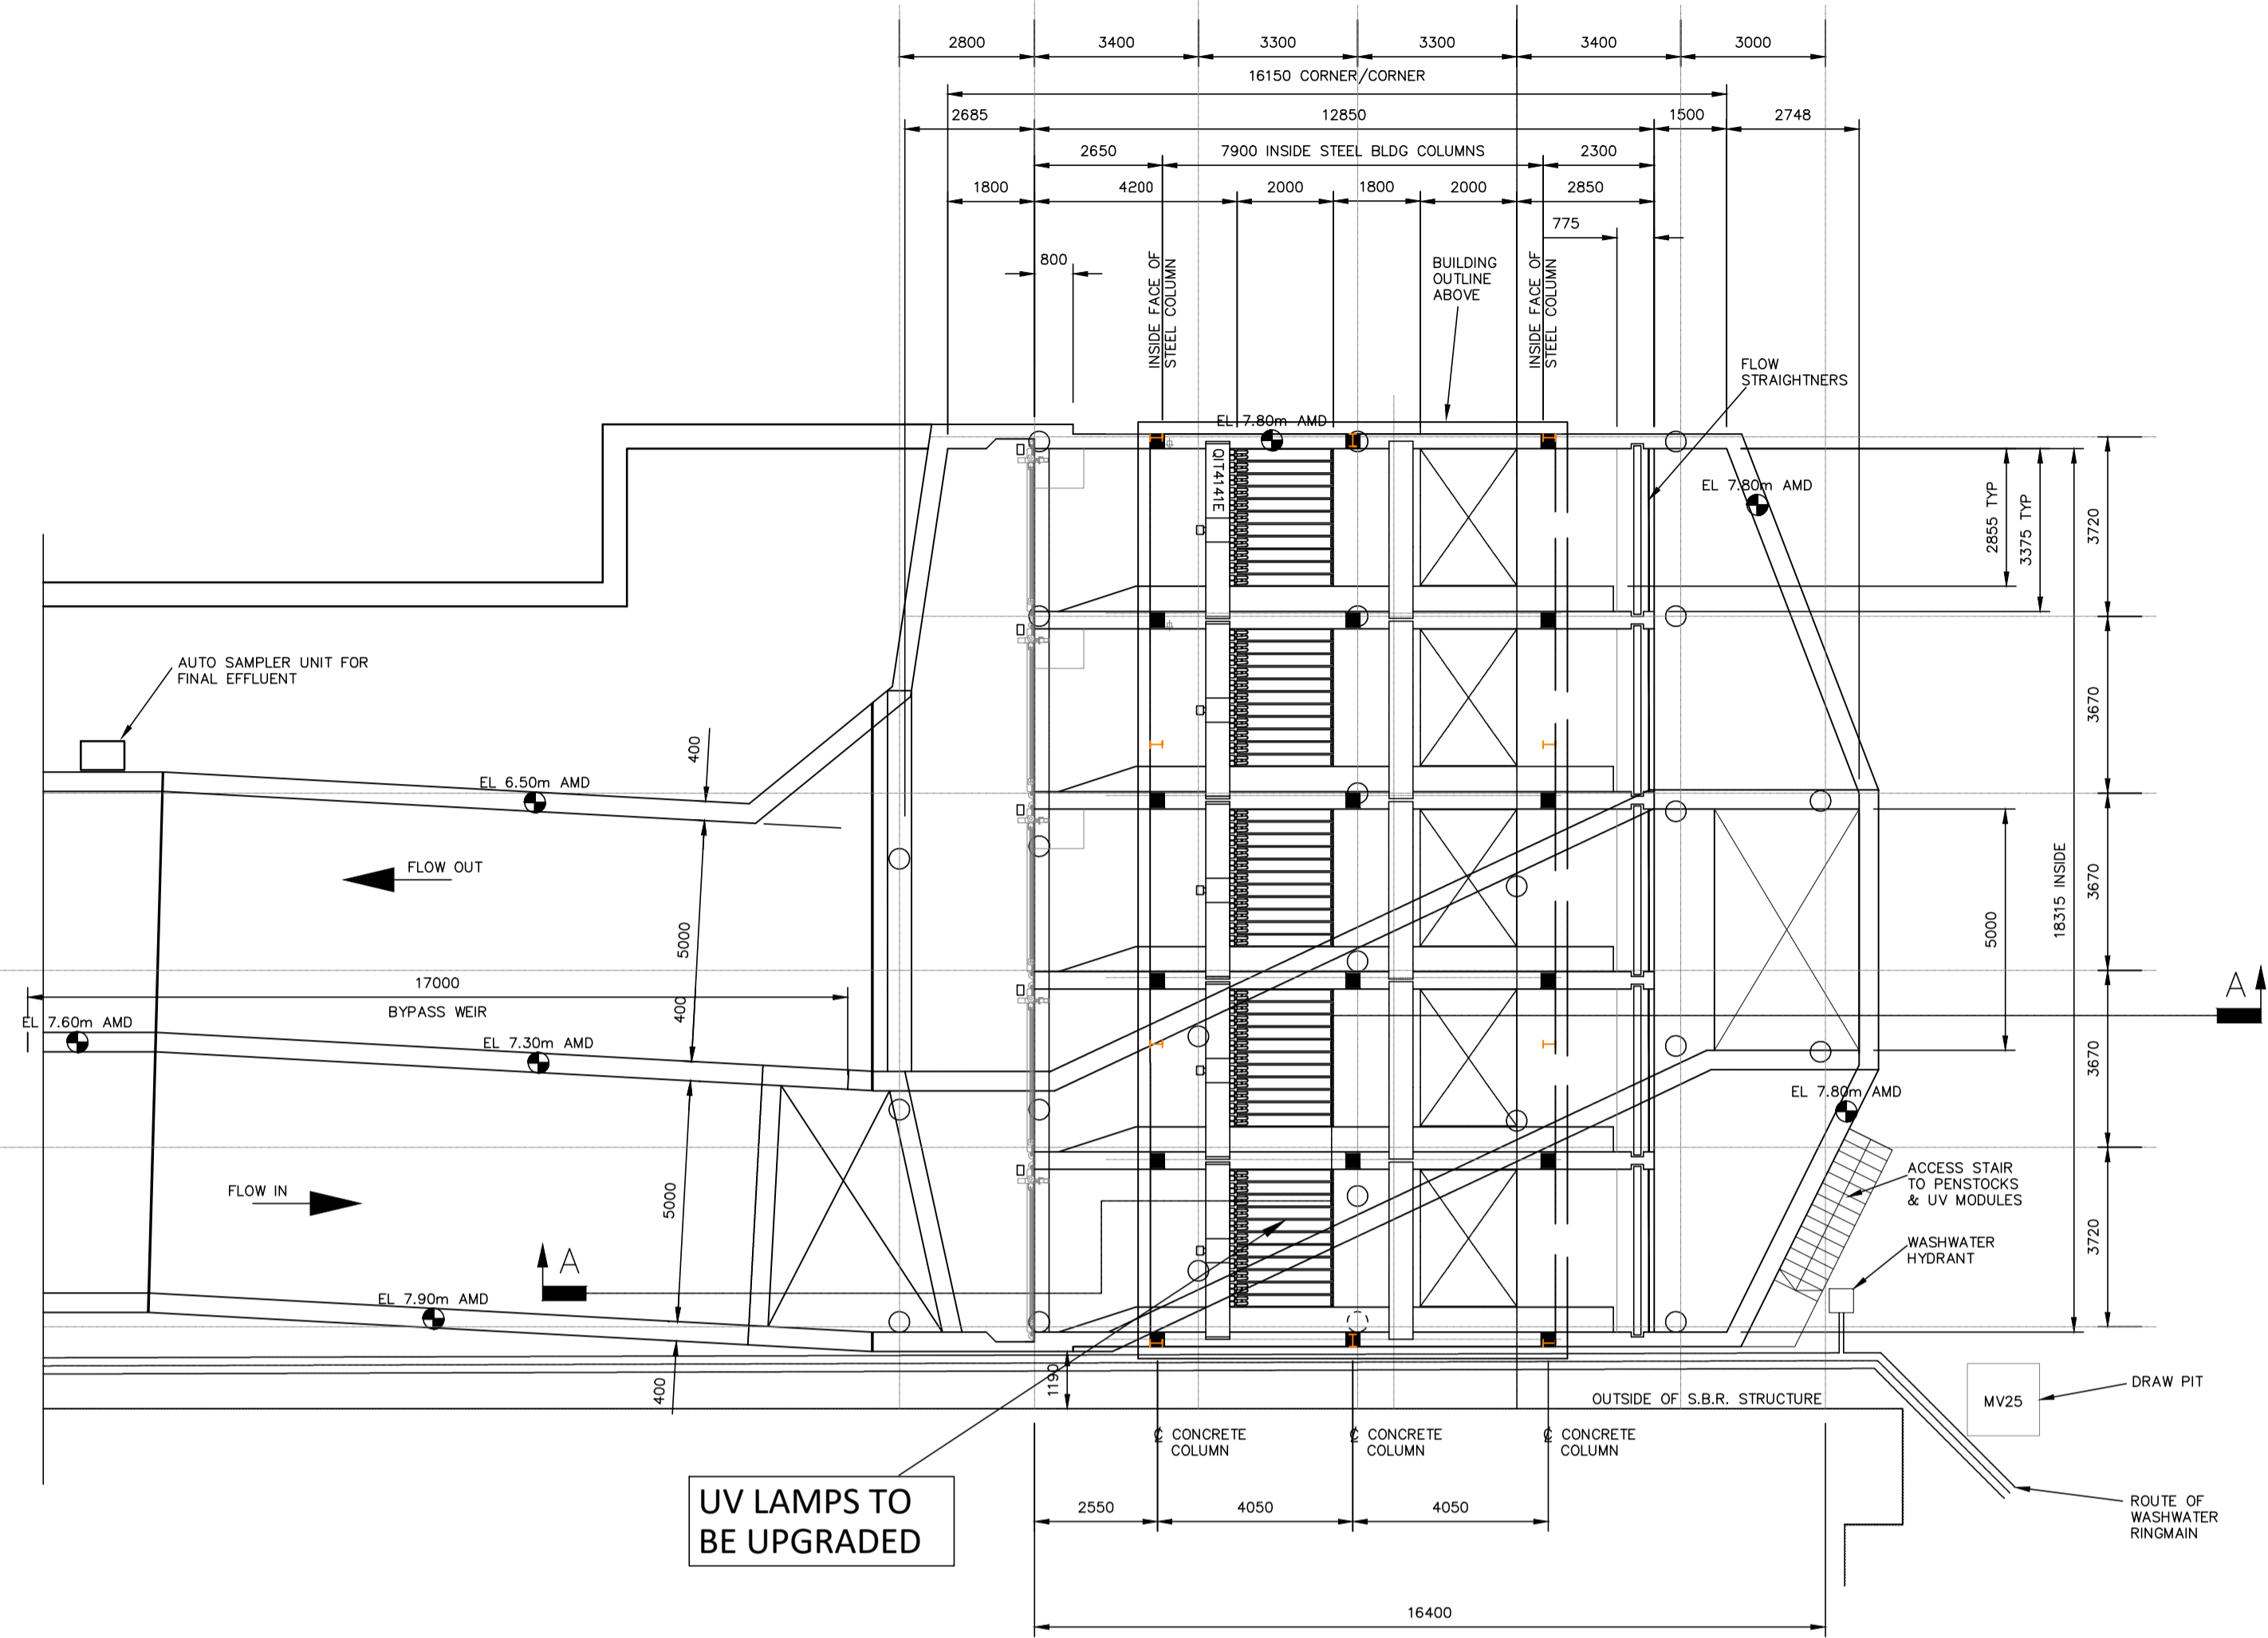


PLAN

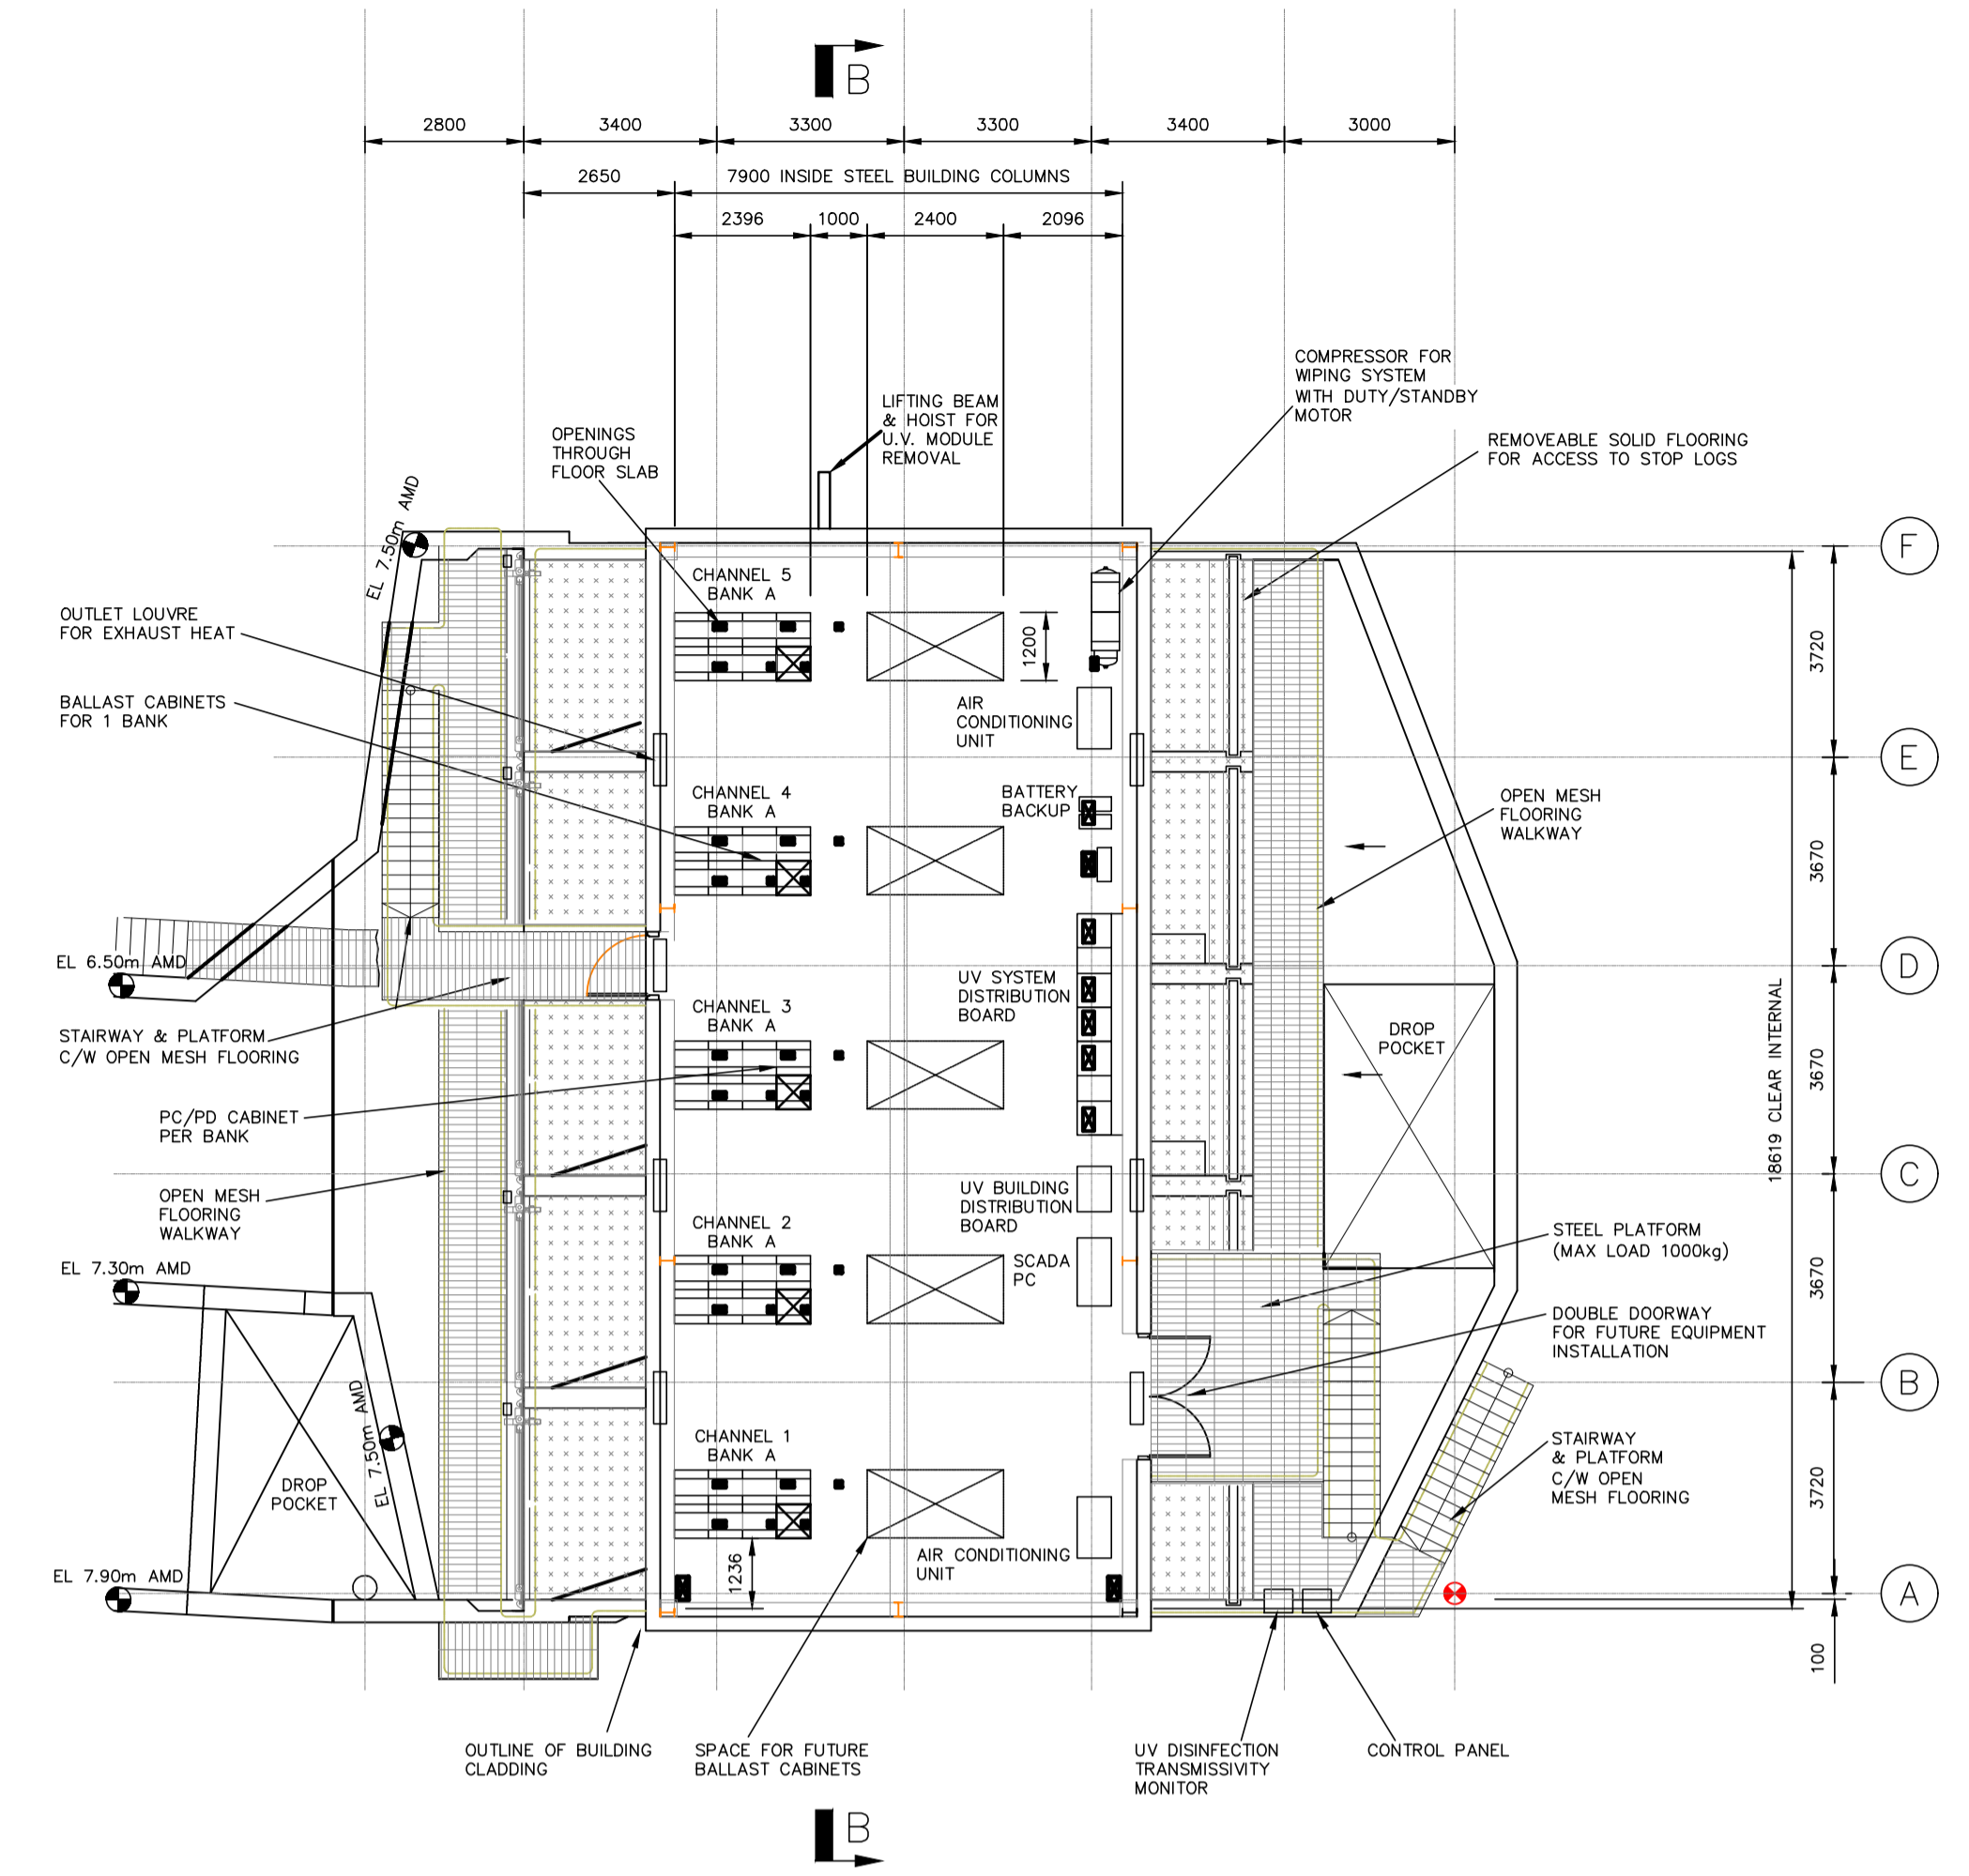


UPPER FLOOR PLAN

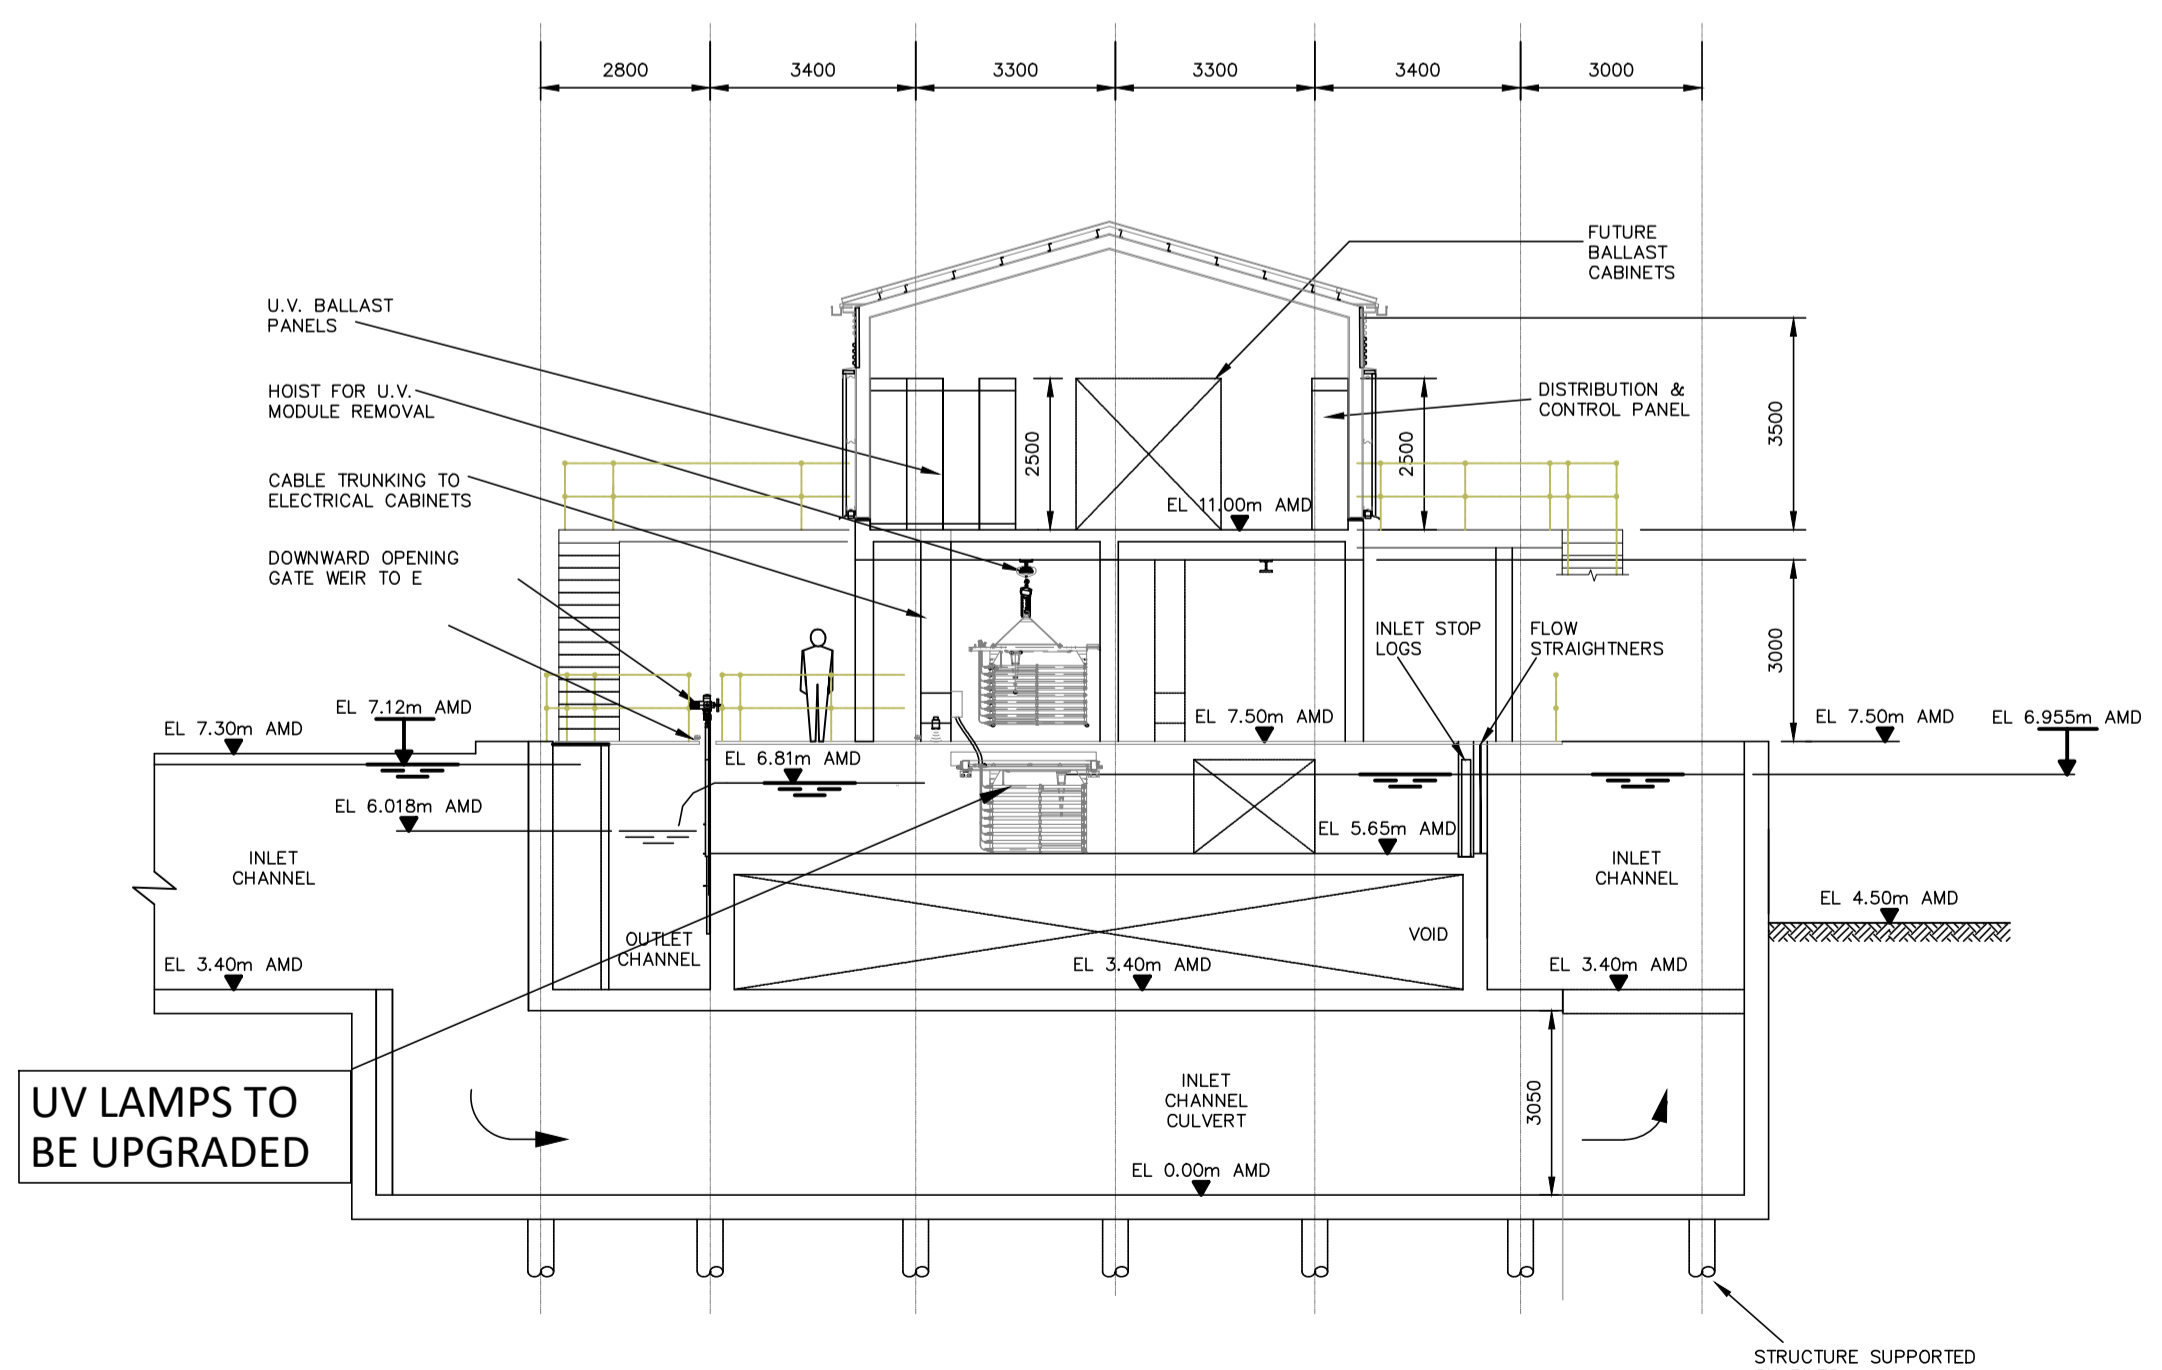

SECTION A-A

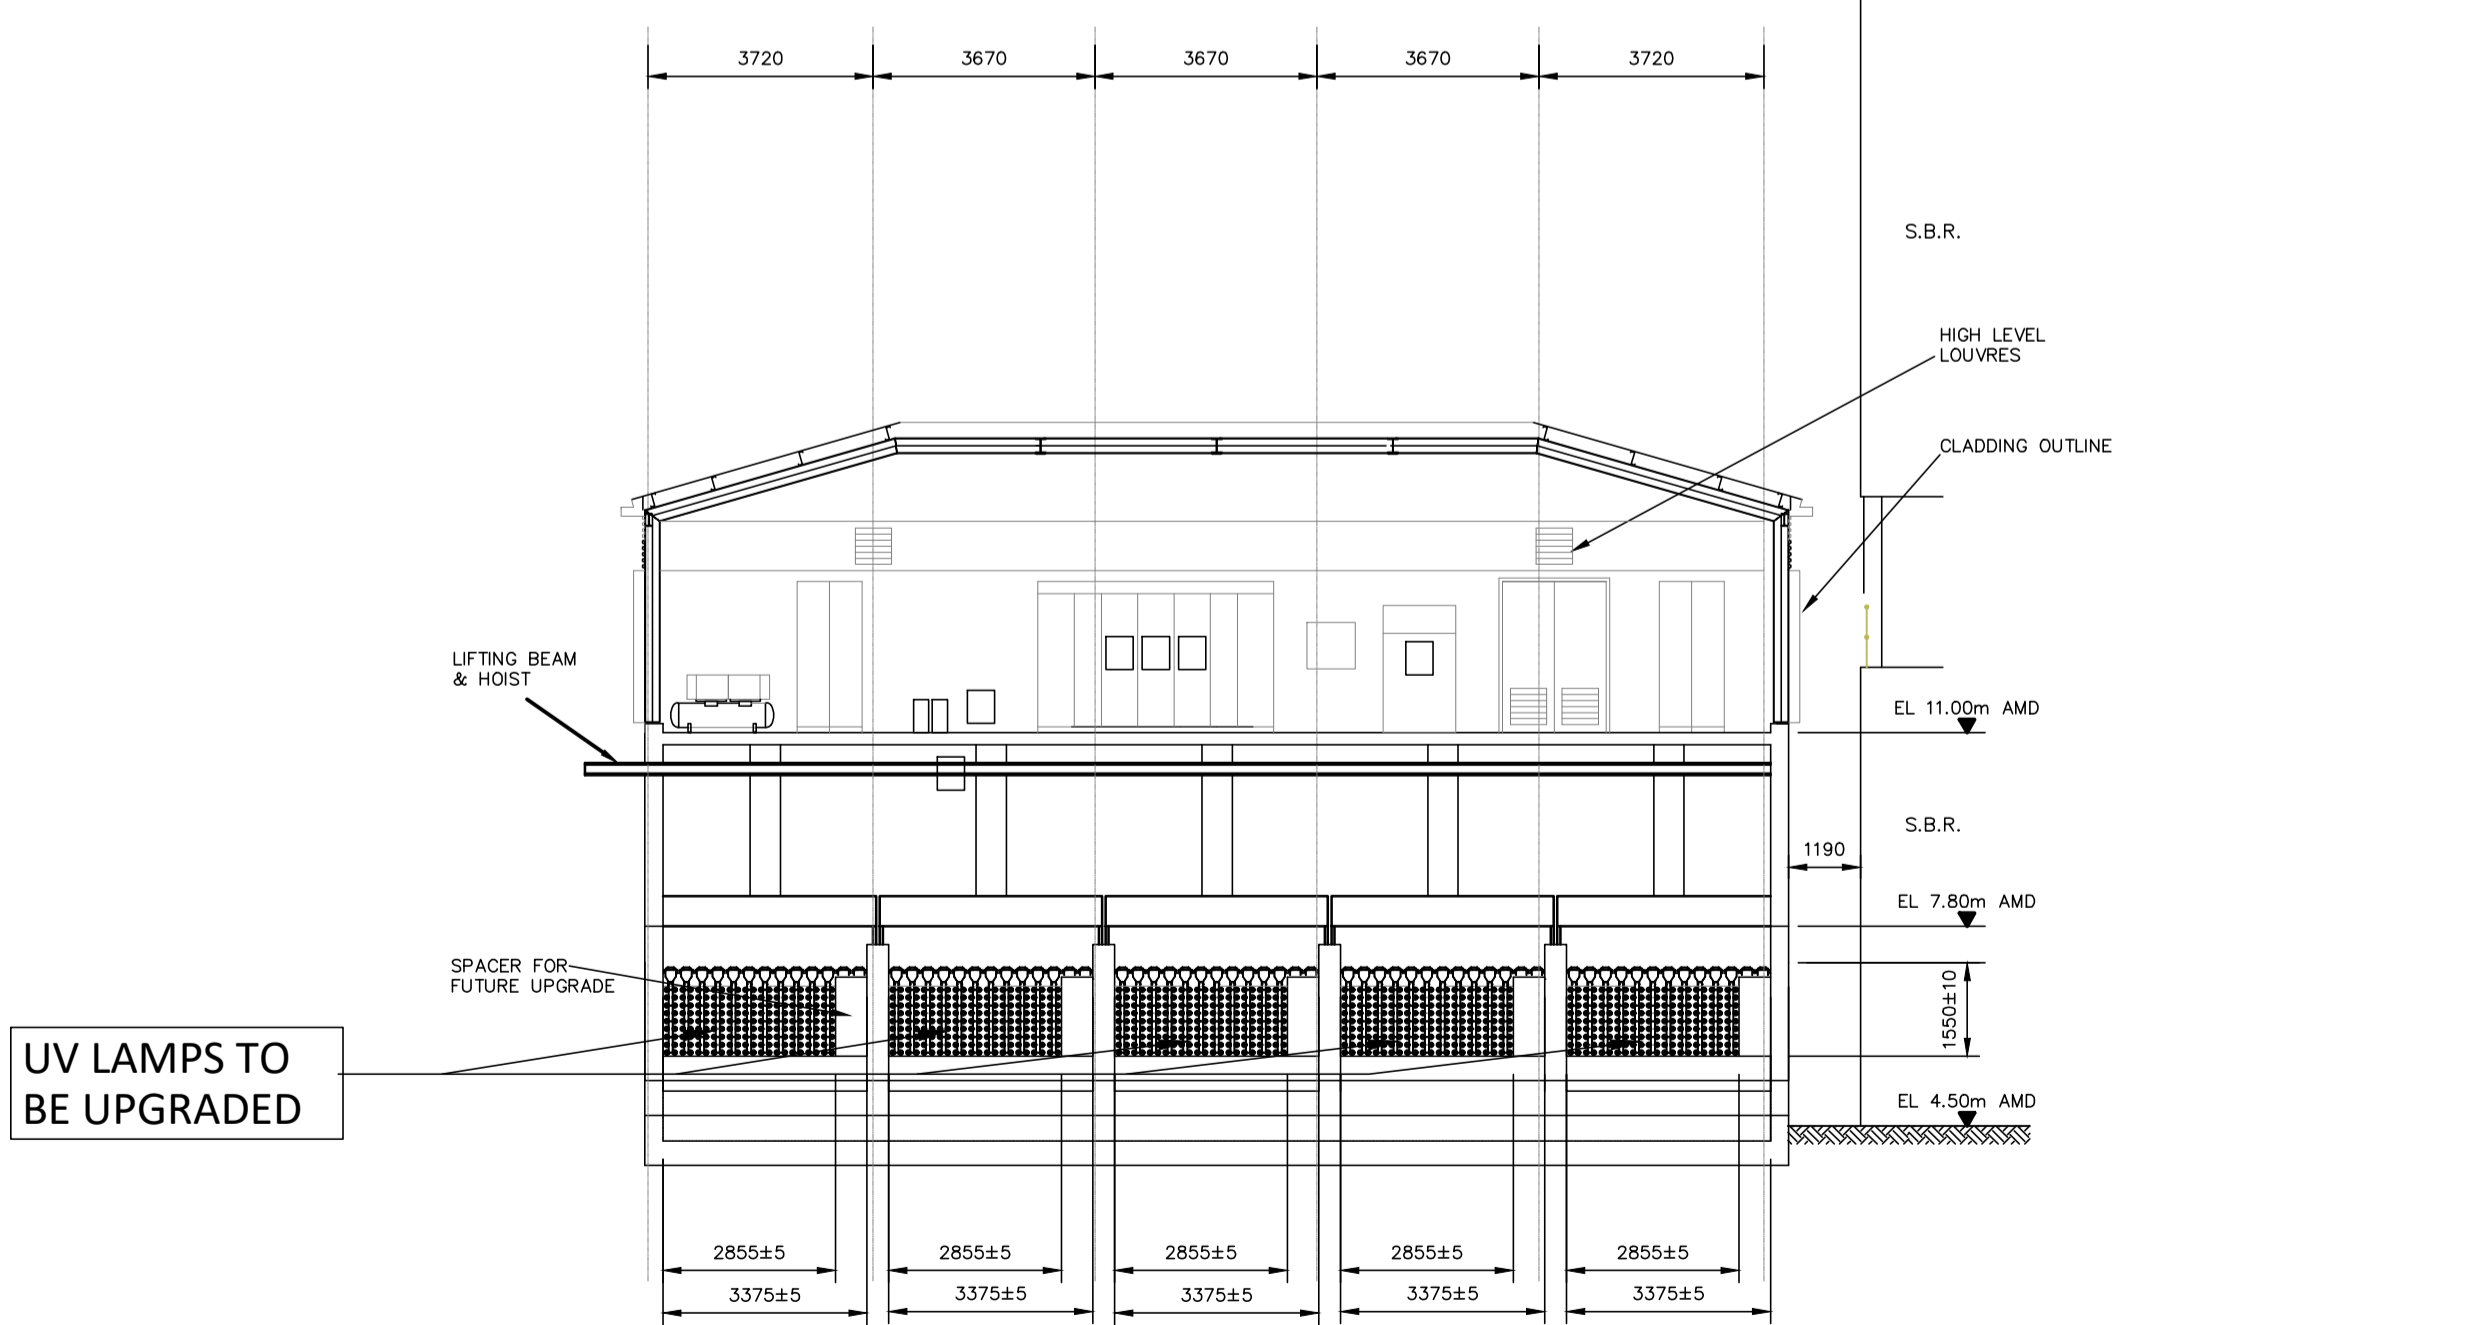

SECTION B-B

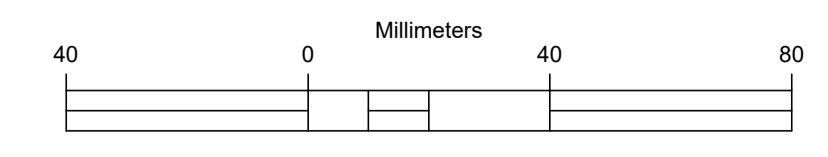

Rev.	Date	Drawn	Checked	Approved	Description
0	JUNE 2018	LA	MH	MH	PLANNING APPLICATION

Client:
UISCE EIREANN : IRISH WATER
 Colvill House 24-26 Talbot St Dublin 1
 Tel: 1890 278 278 Int'l: +353-1-707 2828 email: info@water.ie Web: www.water.ie

Scheme:
 RINGSEND WASTEWATER TREATMENT PLANT UPGRADE PROJECT

Component:
 RINGSEND WASTEWATER TREATMENT PLANT

TJ O'Connor & Associates CONSULTING ENGINEERS
 Corrig Road, Sandyford, Dublin 18, Ireland
 Tel: +353-1-2952321 email: tjoc@iol.ie Web: www.tjoc.ie

J. B. Barry and Partners
 Clason House, Dundrum Business Park, Dublin 14
 Tel: +353-1-485 1400 email: info@jbbarry.ie Web: www.jbbarry.ie

Royal HaskoningDHV
 PO Box 1132, 3800 BC Amersfoort, The Netherlands
 Tel: +31-88-3482000 email: info@rhdhv.com Web: www.royalhaskoningdhv.com

Drawn By:	Checked By:	Approved By:	Date:
LHA	MH	MH	JAN.2018

Client Project Ref: IW-RGD/10000308
 Project Stage:

Internal Project Ref: Ring01/JBB-Y14701/TJOC-14040/RHDHV-BB4342 @A0

Drawing Title:
GENERAL ARRANGEMENT OF U.V. CHANNEL AREA & U.V. DISINFECTANT PLANT

Scale:	1:125@A1	1:300@A3
Drawing No.:	Y15710-PL-959	Rev: 0